


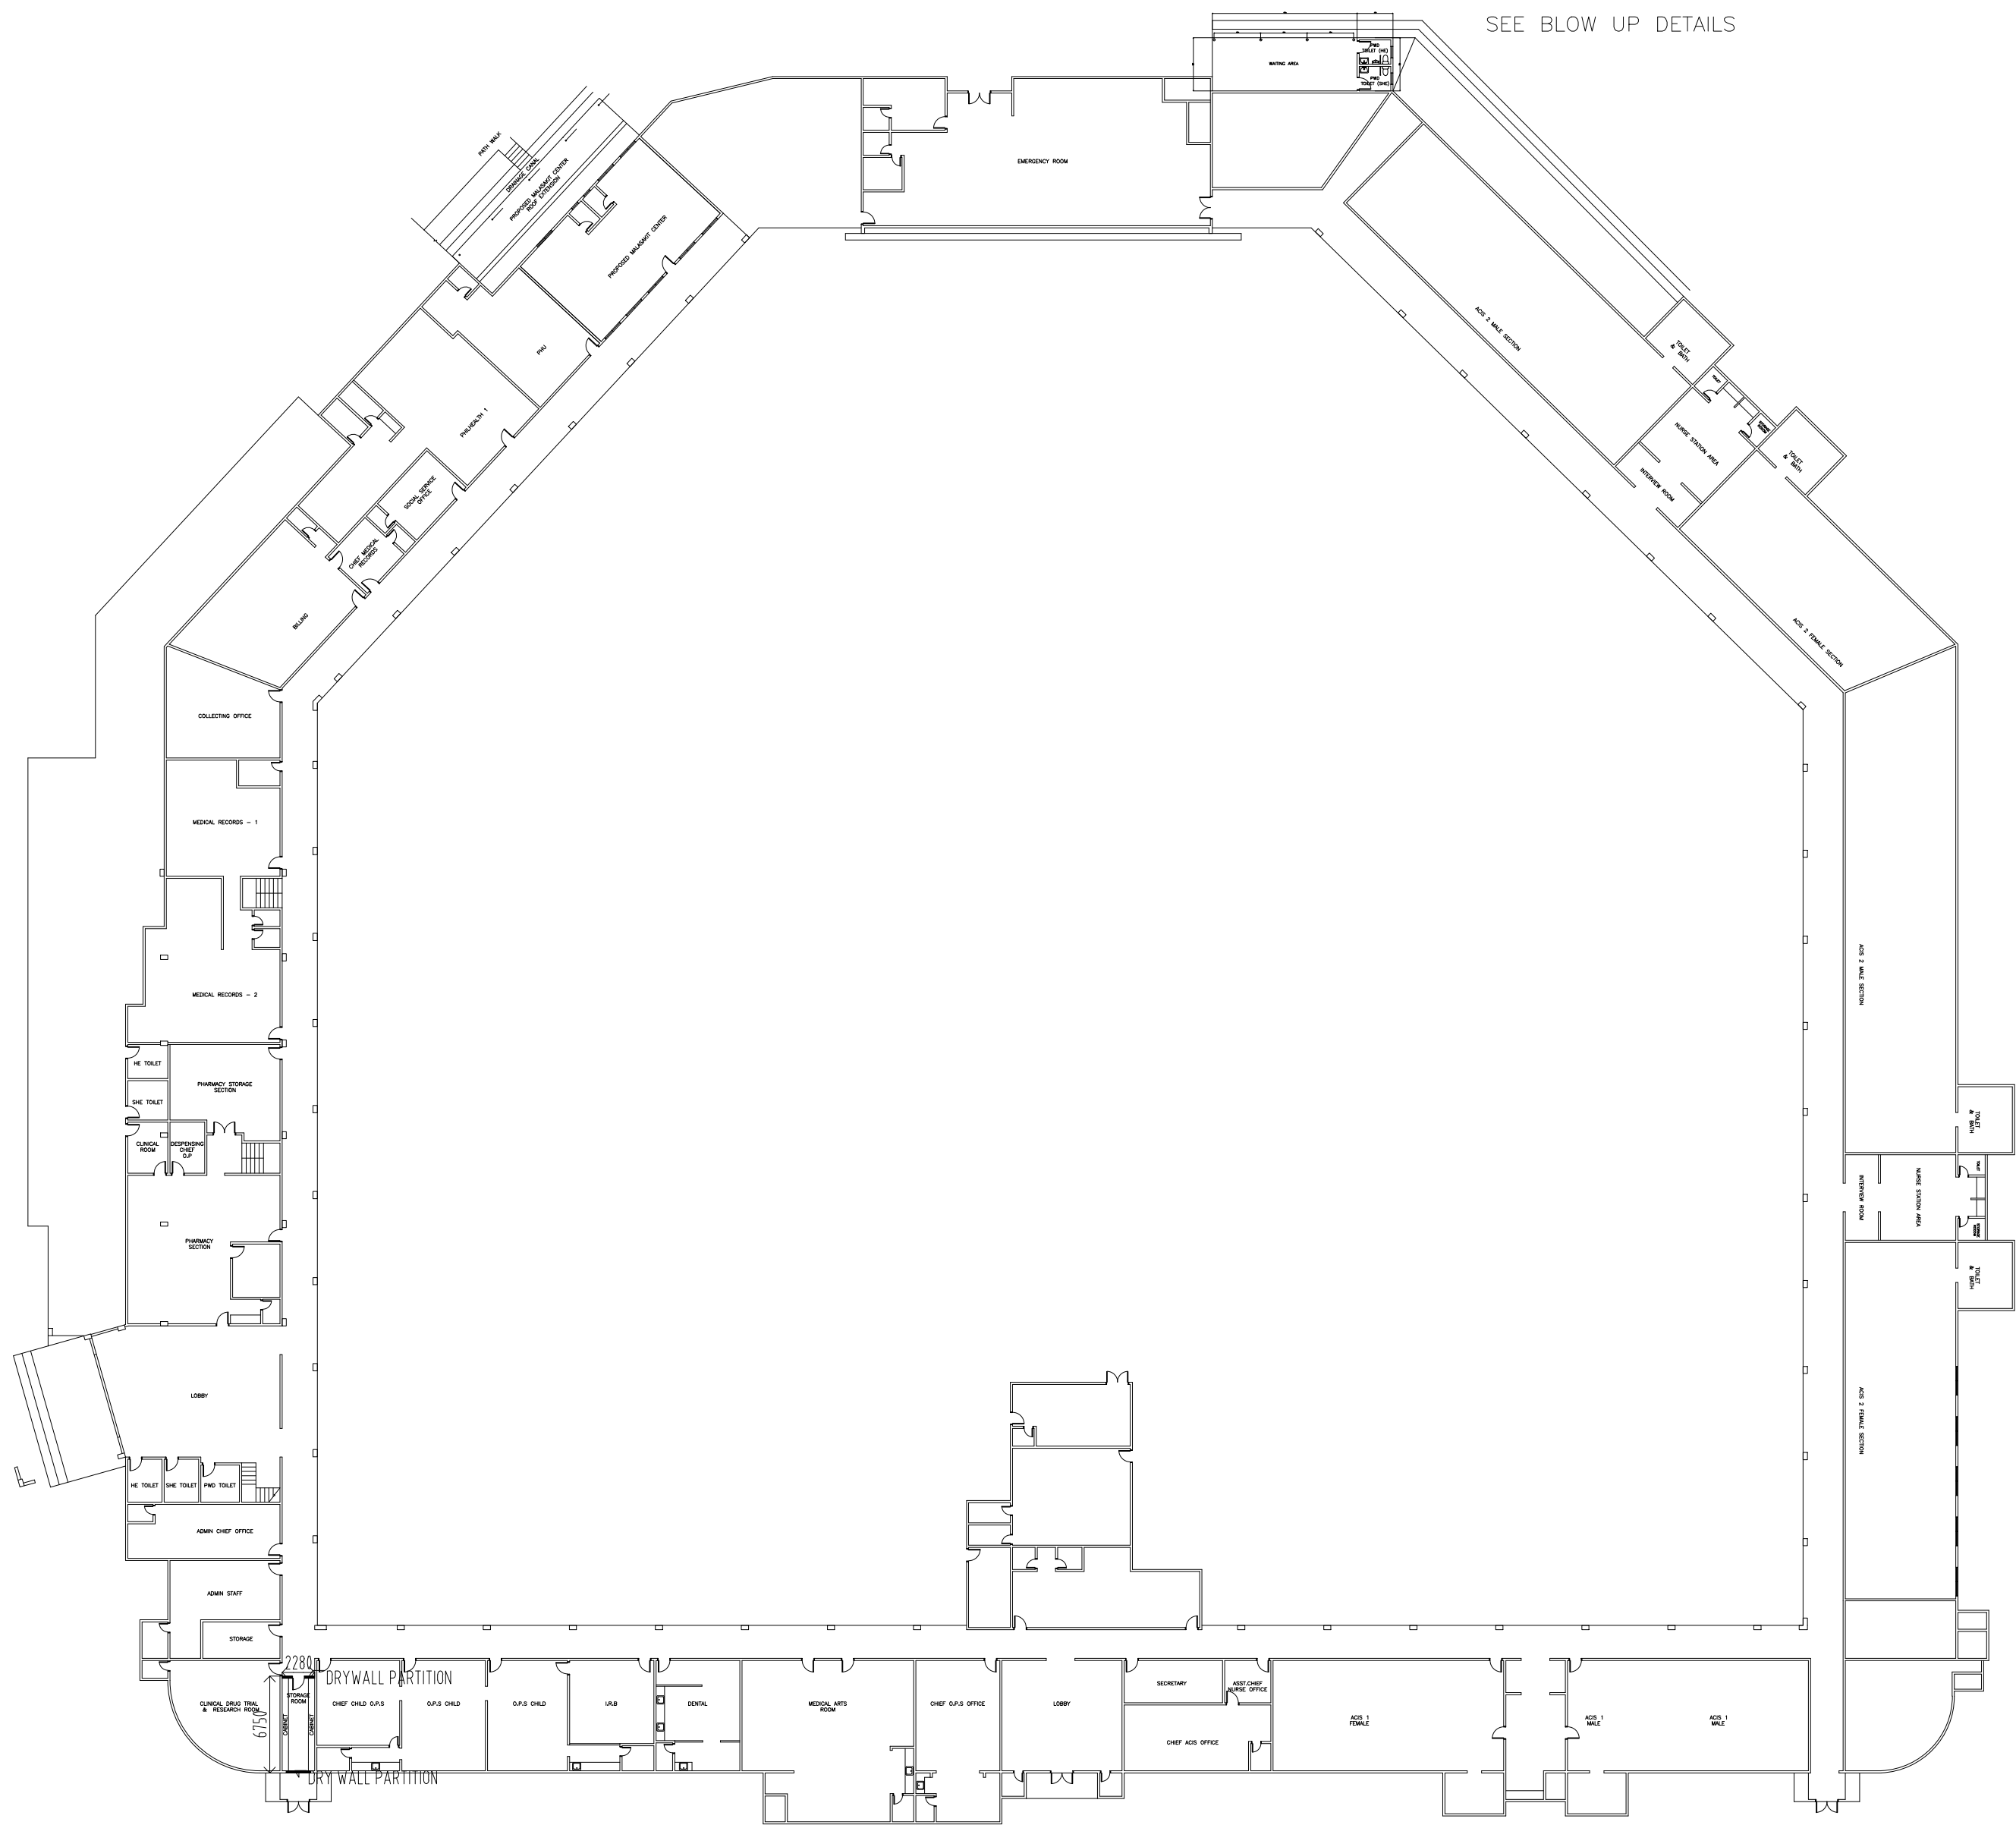

PAVILION 2
PROVISION OF WAITING AREA AT PAVILION 2 EMERGENCY ROOM
1:400M



REPUBLIC OF THE PHILIPPINES
Department Of Health
National Center for Mental Health
Nueve de Pebrero Street, Baranggay Mauway, Mandaluyong City

PROJECT TITLE/LOCATION:

PROVISION OF WAITING AREA AT PAVILION 2
EMERGENCY ROOM

PREPARED BY:

EVELYN T. PURINO, CE, MMHoA
SAO, Chief, Planning & Development Section

REVIEWED:

DIONICIO A. TOLENTINO, MPA
Chief Finance Service, HFEP Coordinator


RECOMMENDING APPROVAL:


NOEL V. REYES, MD, FPPA, MMHoA
Medical Center Chief II

SHEET CONTENT:


PAVILION 2 KEY PLAN

SHEET NO.

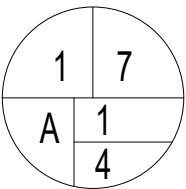

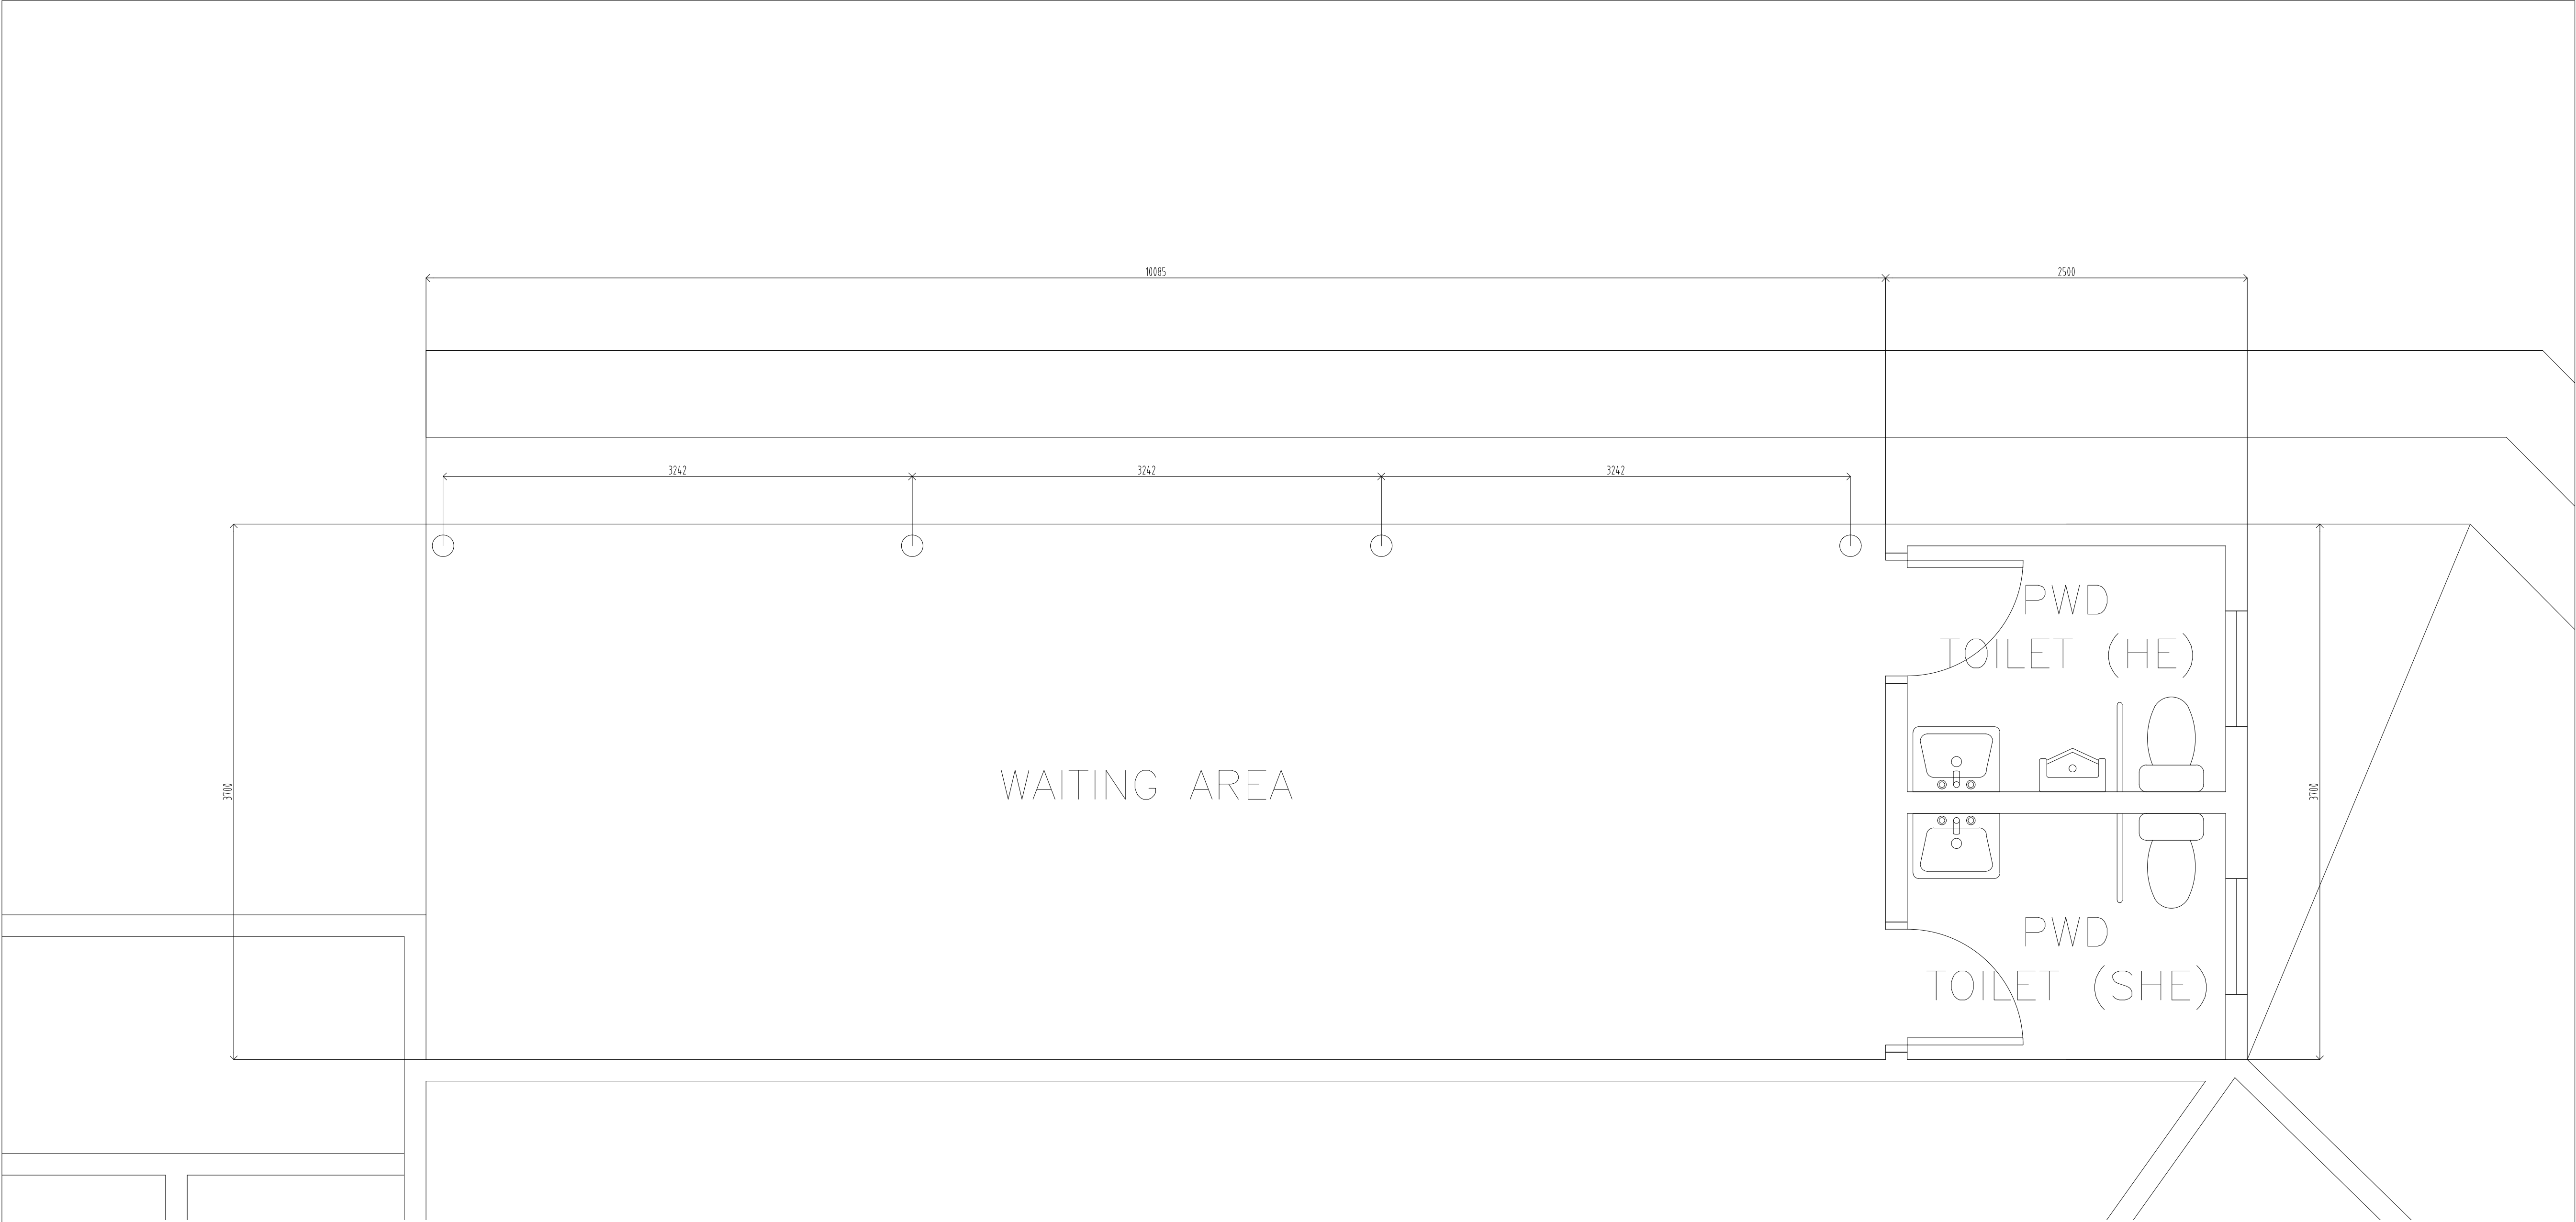

PAVILION 2 (BLOW UP DETAILS)
A **PROVISION OF WAITING AREA AT PAVILION 2 EMERGENCY ROOM**
202 1:25M






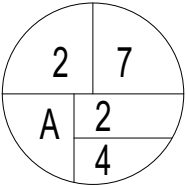
	REPUBLIC OF THE PHILIPPINES Department Of Health National Center for Mental Health Nueve de Pebrero Street, Baranggay Mauway, Mandaluyong City	PROJECT TITLE/LOCATION:	PREPARED BY:	REVIEWED:	RECOMMENDING APPROVAL:	SHEET CONTENT:	SHEET NO.
		PROVISION OF WAITING AREA AT PAVILION 2 EMERGENCY ROOM	EVELYN T. PURINO, CE, MMHoA SAO, Chief, Planning & Development Section	DIONICIO A. TOLENTINO, MPA Chief Finance Service, HFEP Coordinator	NOEL V. REYES, MD, FPPA, MMHoA Medical Center Chief II	PAVILION 2 EMERGENCY ROOM PLAN	




P E R S P E C T I V E S




	REPUBLIC OF THE PHILIPPINES Department Of Health National Center for Mental Health Nueve de Pebrero Street, Baranggay Mauway, Mandaluyong City	PROJECT TITLE/LOCATION:	PREPARED BY:	REVIEWED:	RECOMMENDING APPROVAL:	SHEET CONTENT: PERSPECTIVE	SHEET NO. 37 A34
		PROVISION OF WAITING AREA AT PAVILION 2 EMERGENCY ROOM	EVELYN T. PURINO, CE, MMHoA SAO, Chief, Planning & Development Section	DIONICIO A. TOLENTINO, MPA Chief Finance Service, HFEP Coordinator	NOEL V. REYES, MD, FPPA, MMHoA Medical Center Chief II		

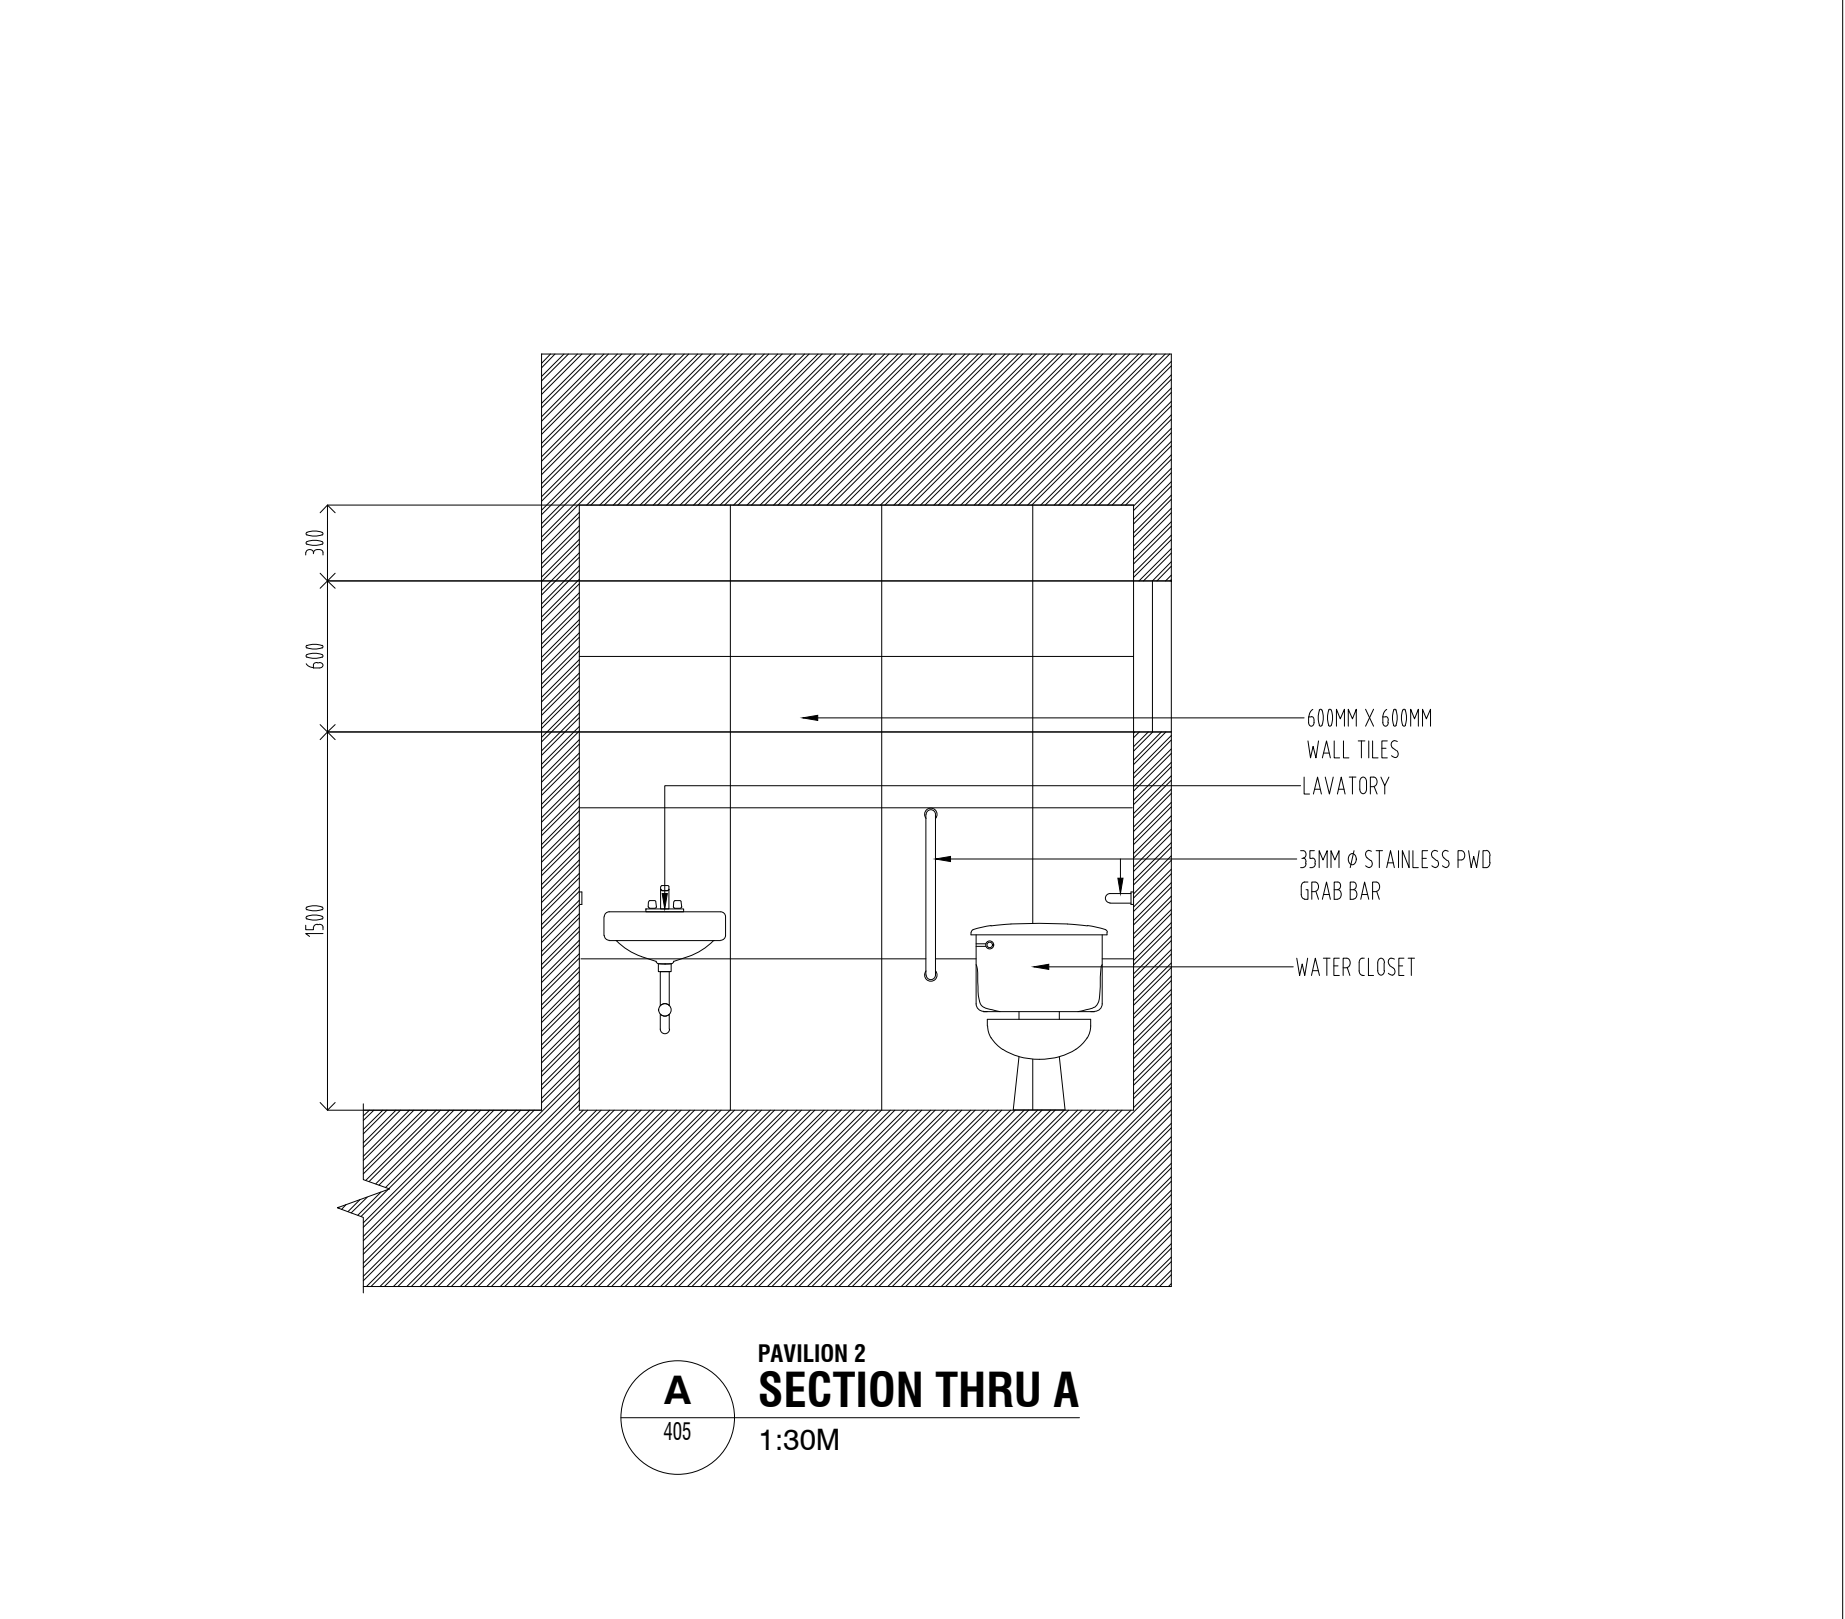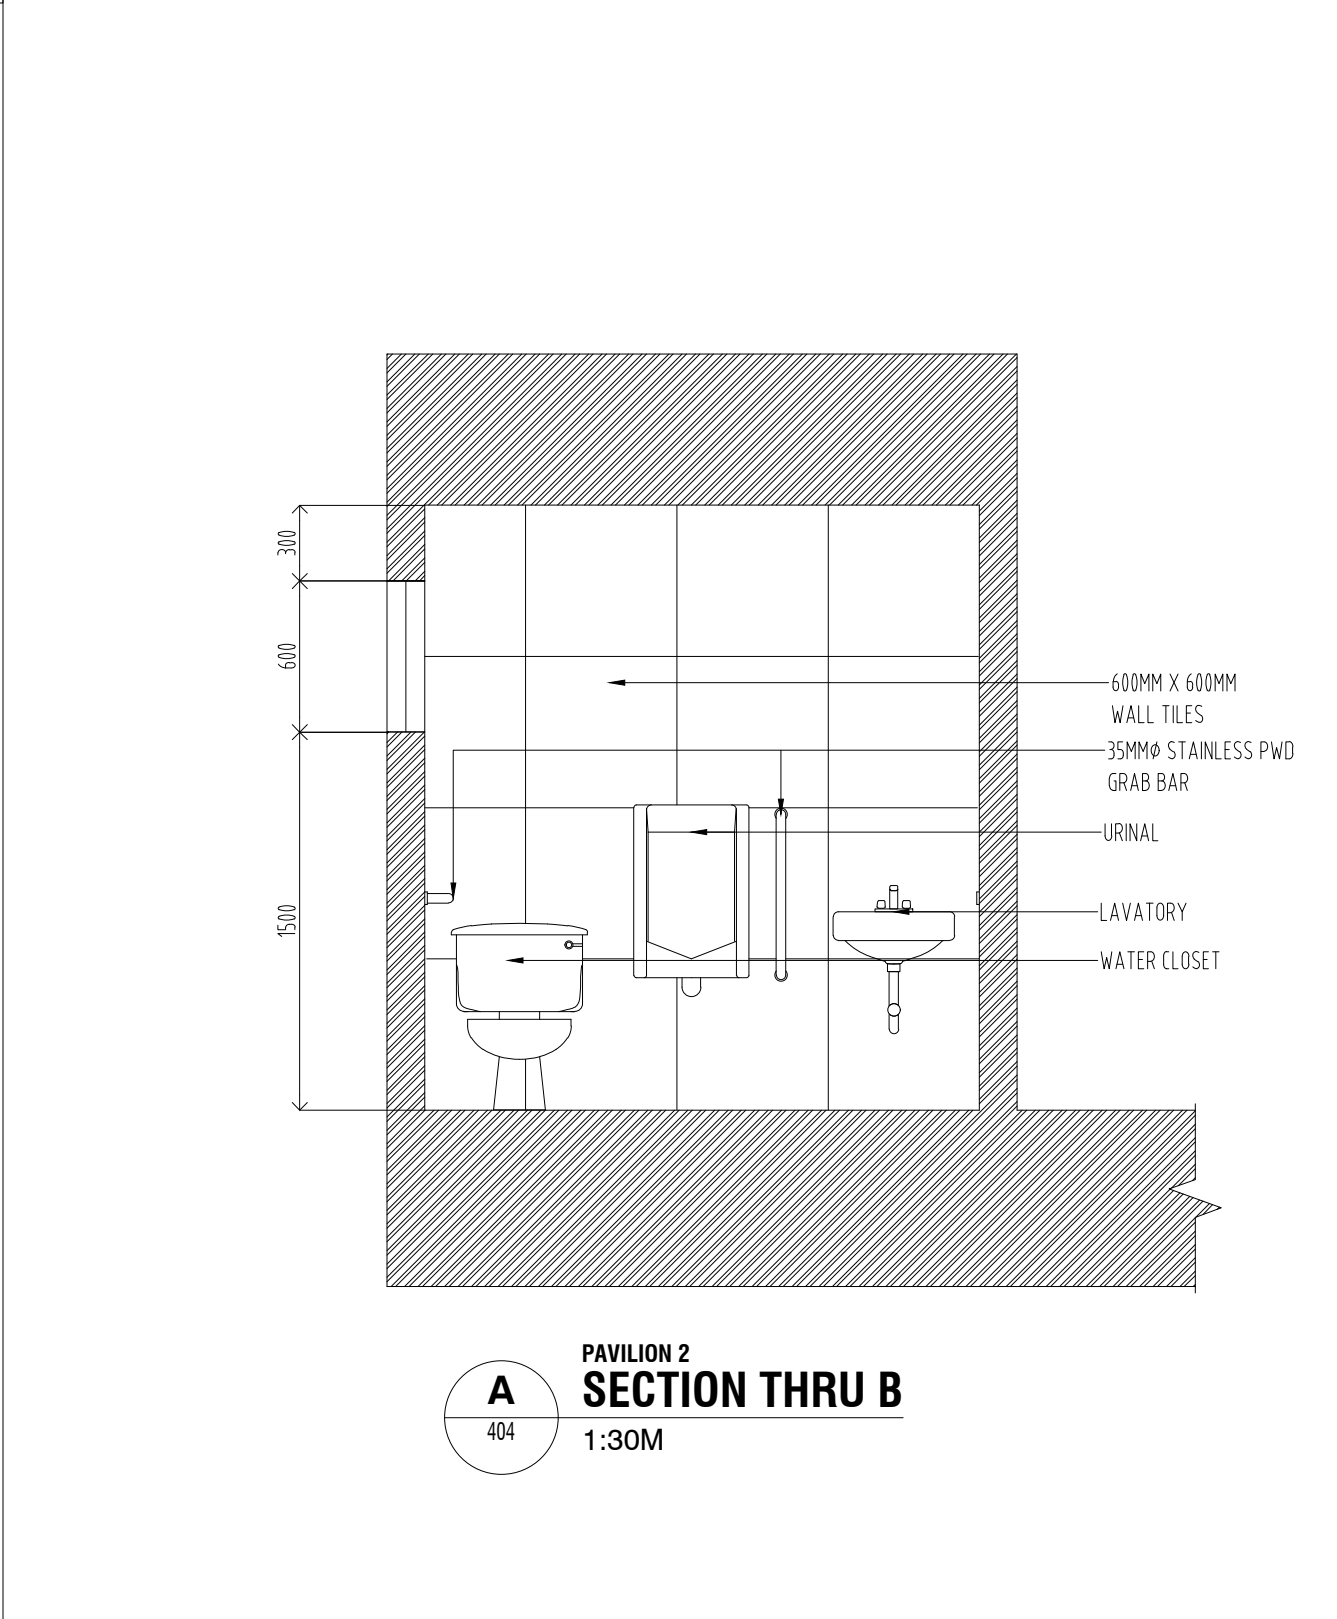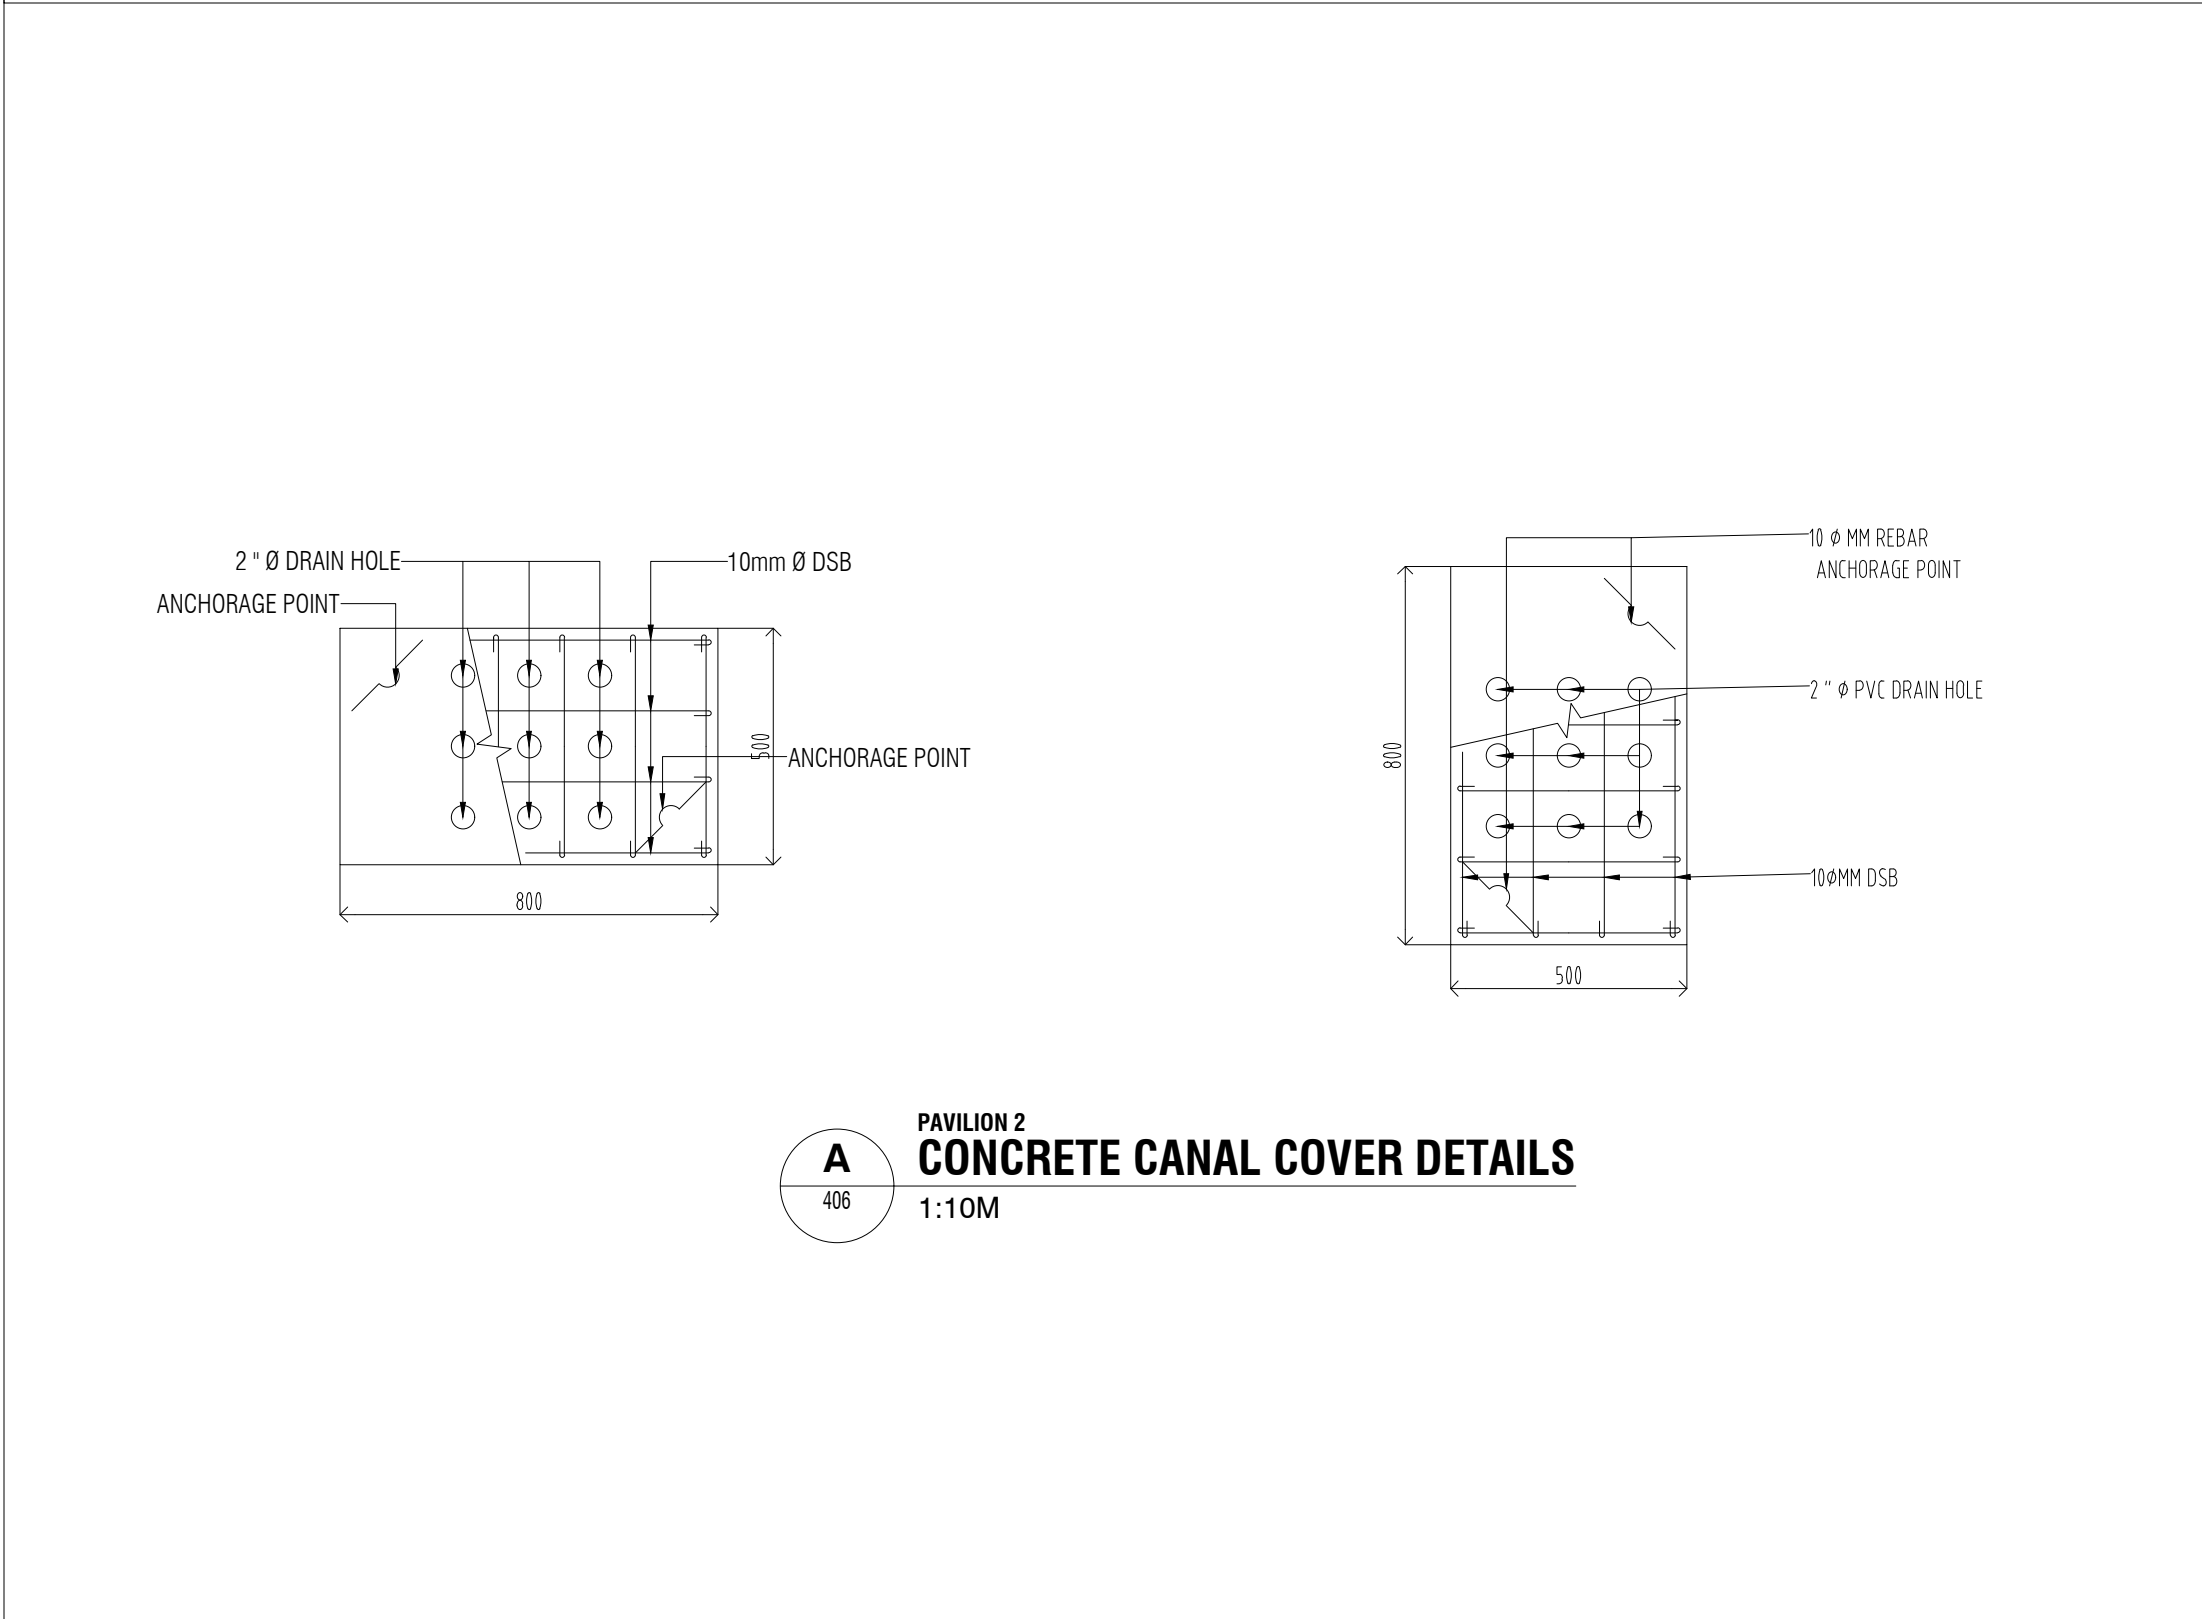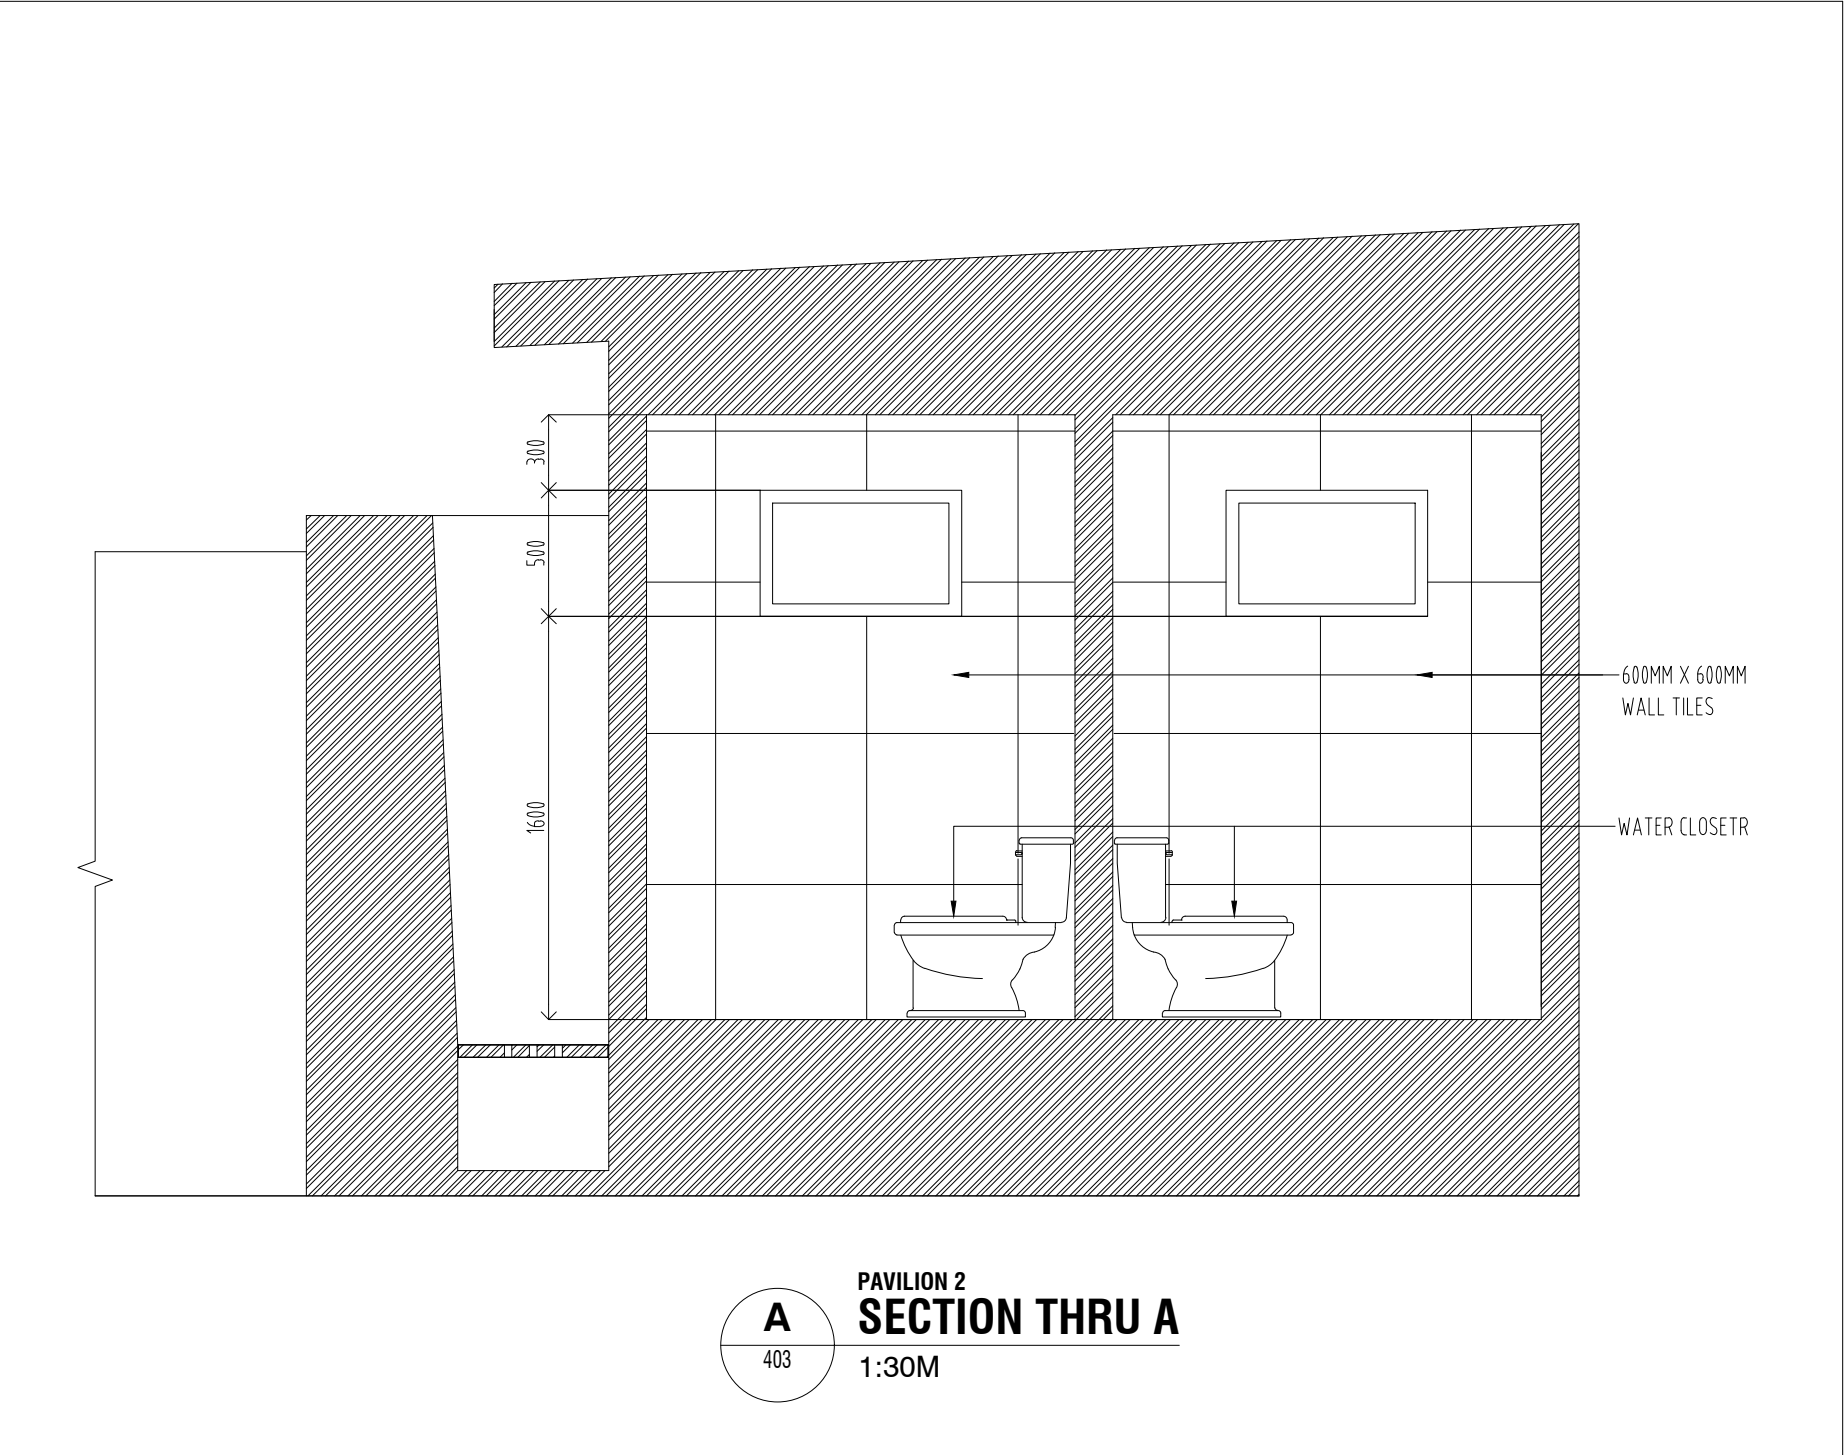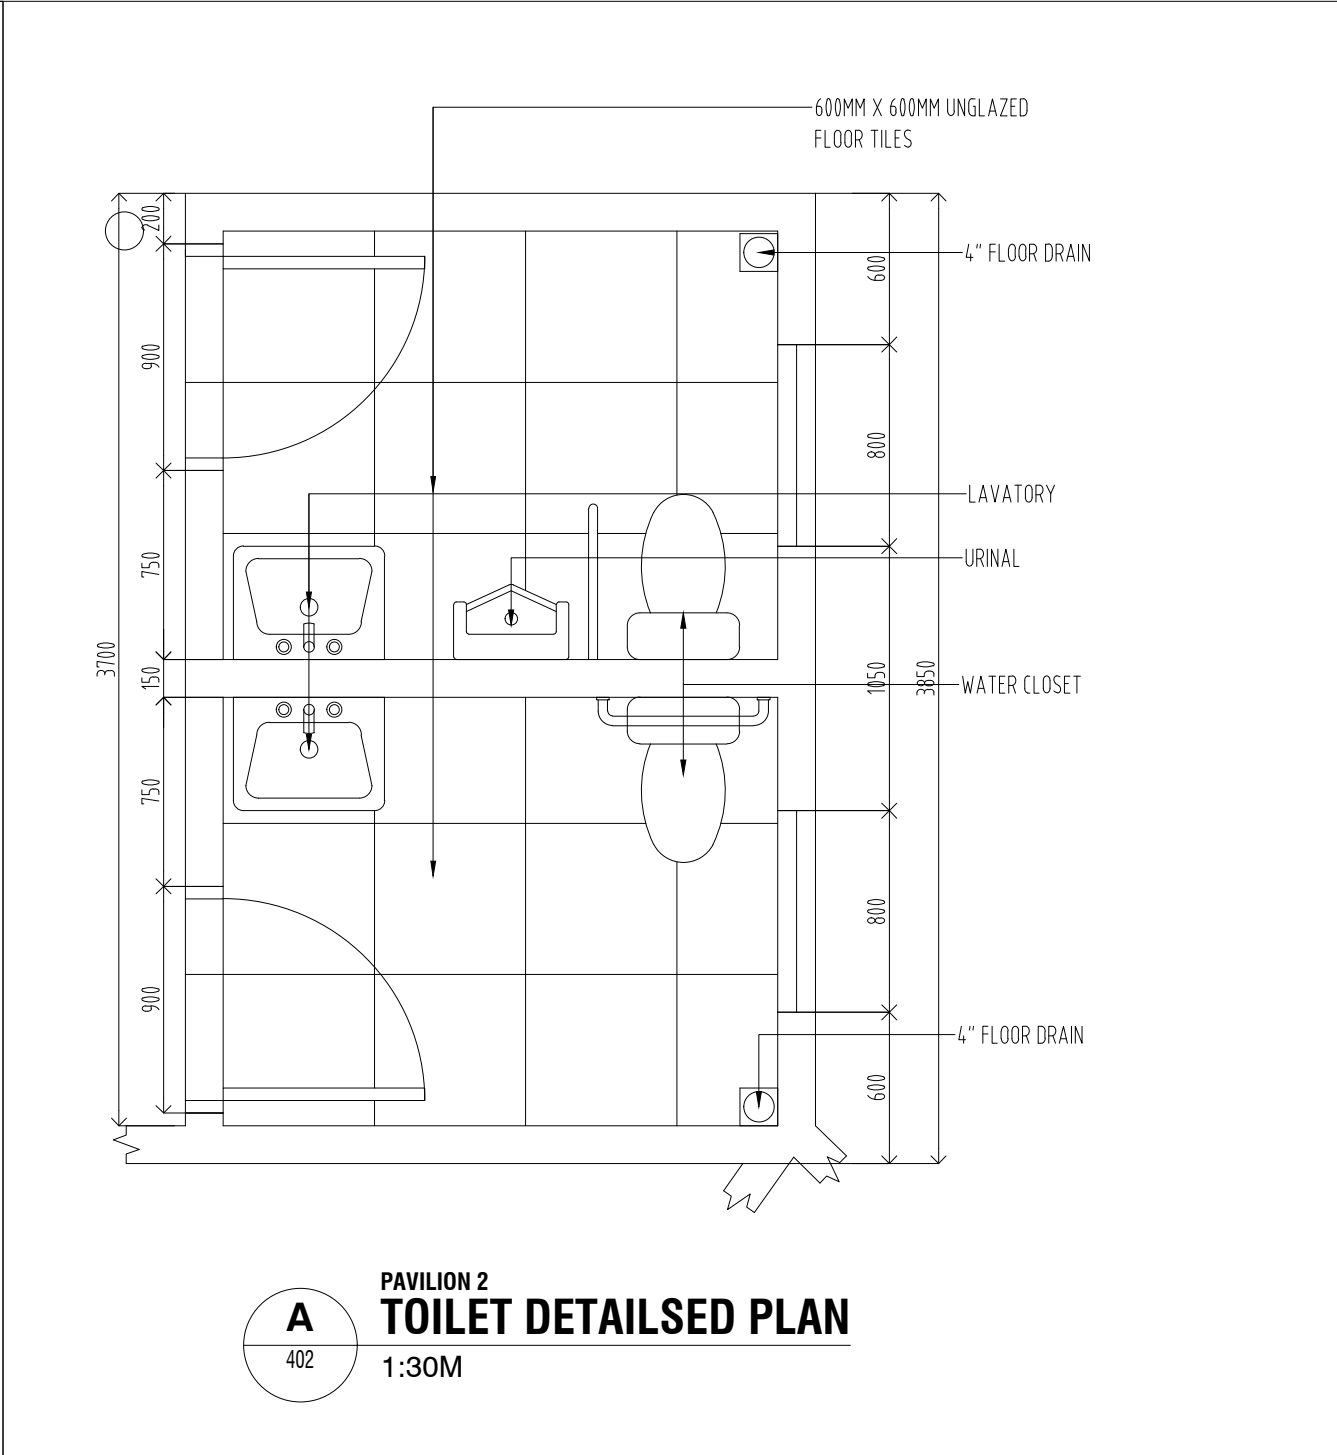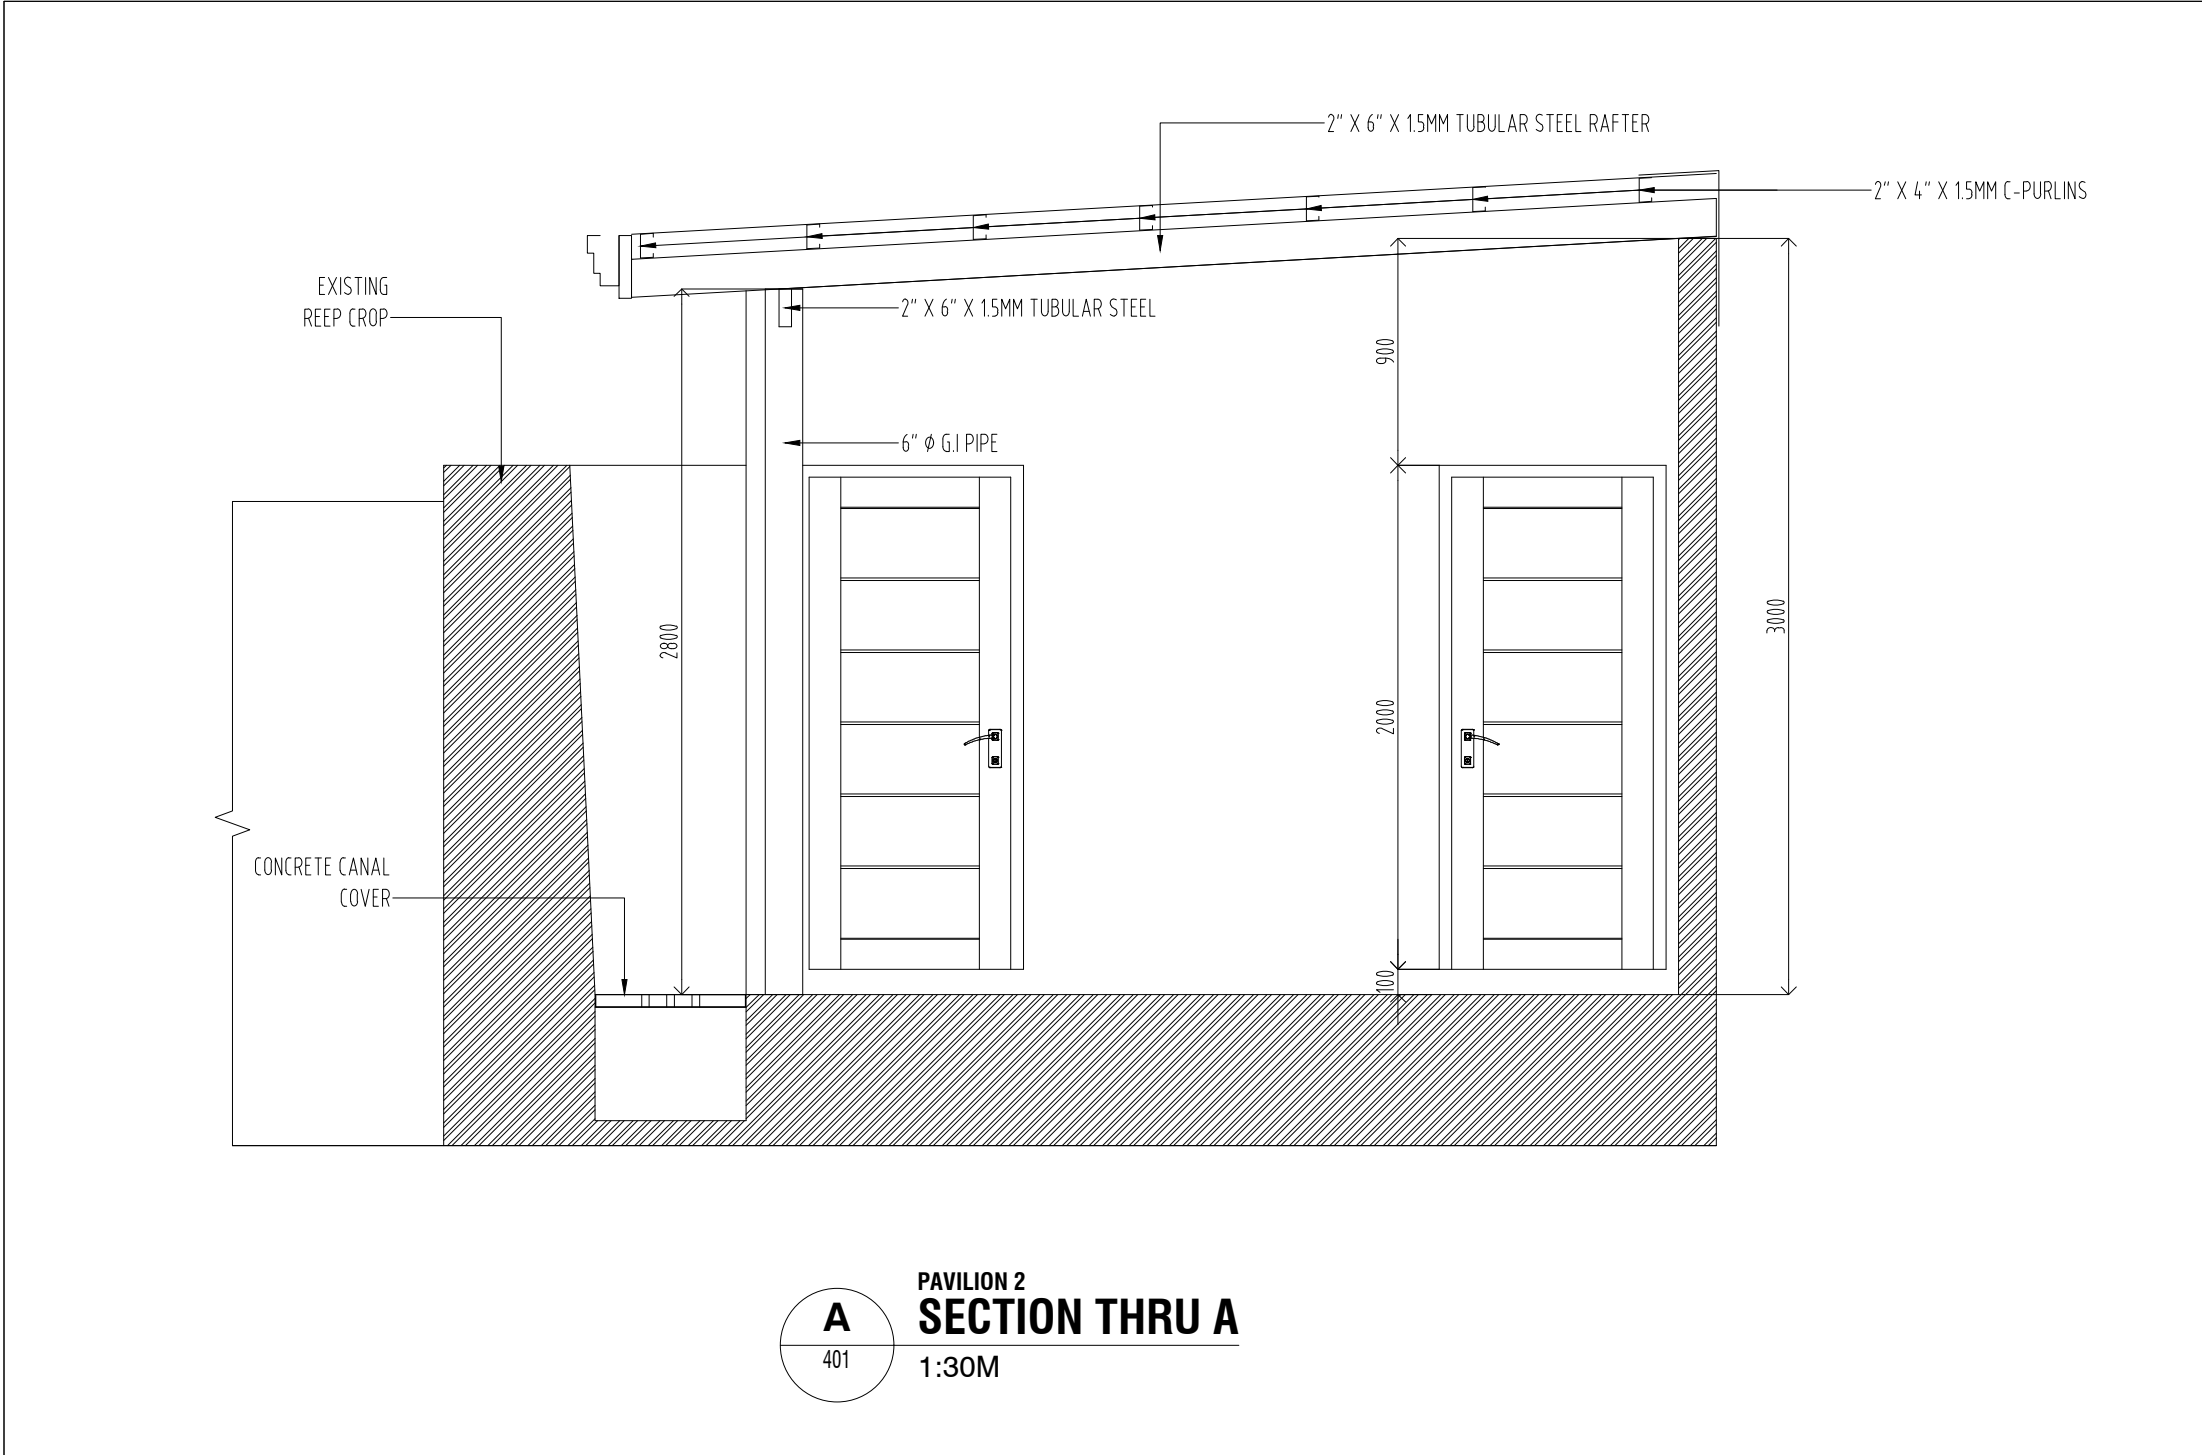

	REPUBLIC OF THE PHILIPPINES Department Of Health National Center for Mental Health Nueve de Pebrero Street, Baranggay Mauway, Mandaluyong City	PROJECT TITLE/LOCATION:	PREPARED BY:	REVIEWED:	RECOMMENDING APPROVAL:	SHEET CONTENT: SECTION DETAILED PLAN OF PUBLIC TOILET CONCRETE CANAL COVER DETAILS	SHEET NO. 47 A44
		PROVISION OF WAITING AREA AT PAVILION 2 EMERGENCY ROOM	EVELYN T. PURINO, CE, MMHoA	DIONICIO A. TOLENTINO, MPA	NOEL V. REYES, MD, FPPA, MMHoA		
			SAO, Chief, Planning & Development Section	Chief Finance Service, HFEP Coordinator	Medical Center Chief II		

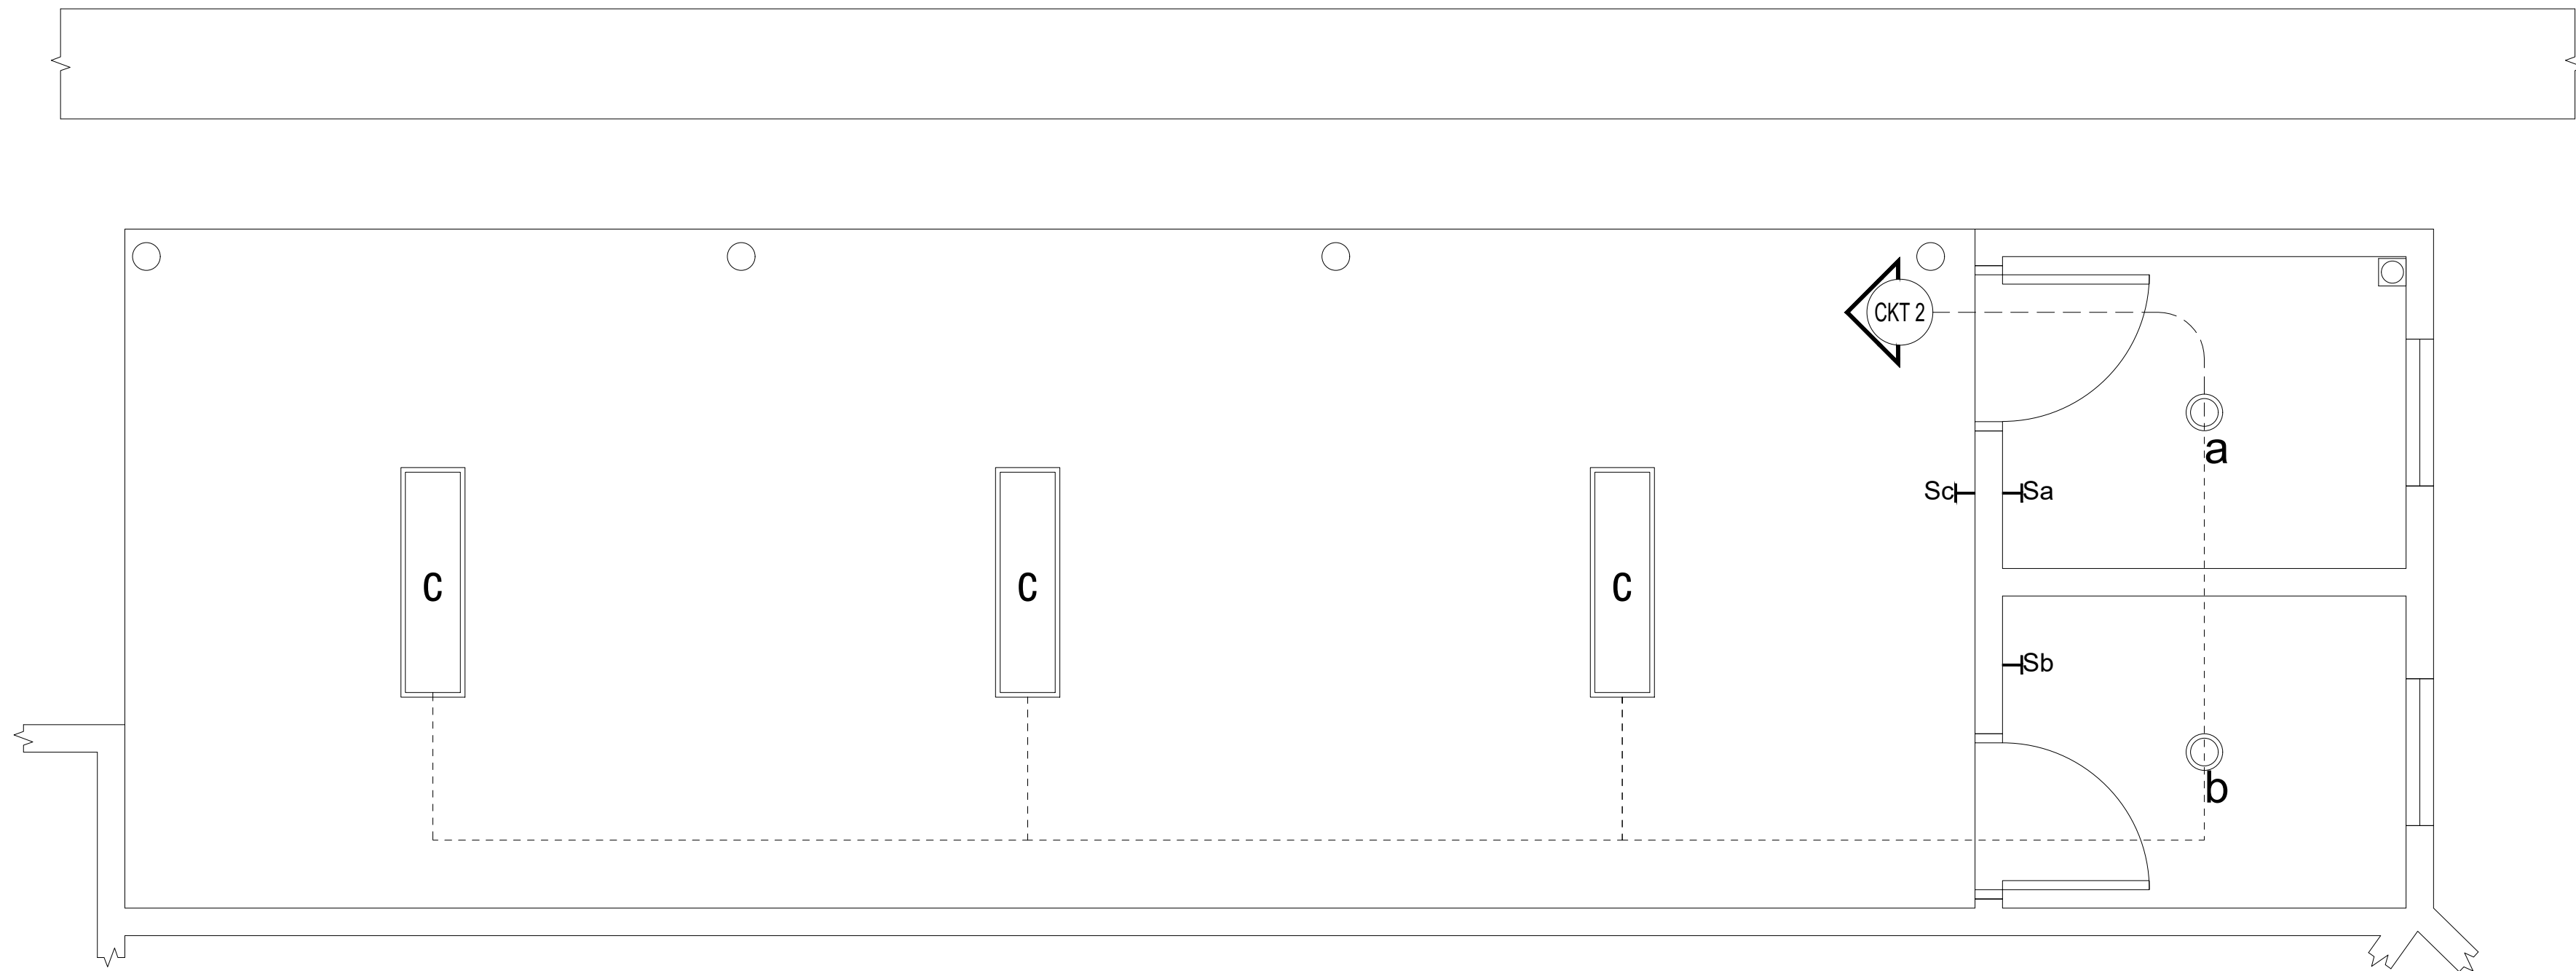

PAVILION 2 E.R
S **PROPOSED LIGHTING LAY OUT**
501 1:30M

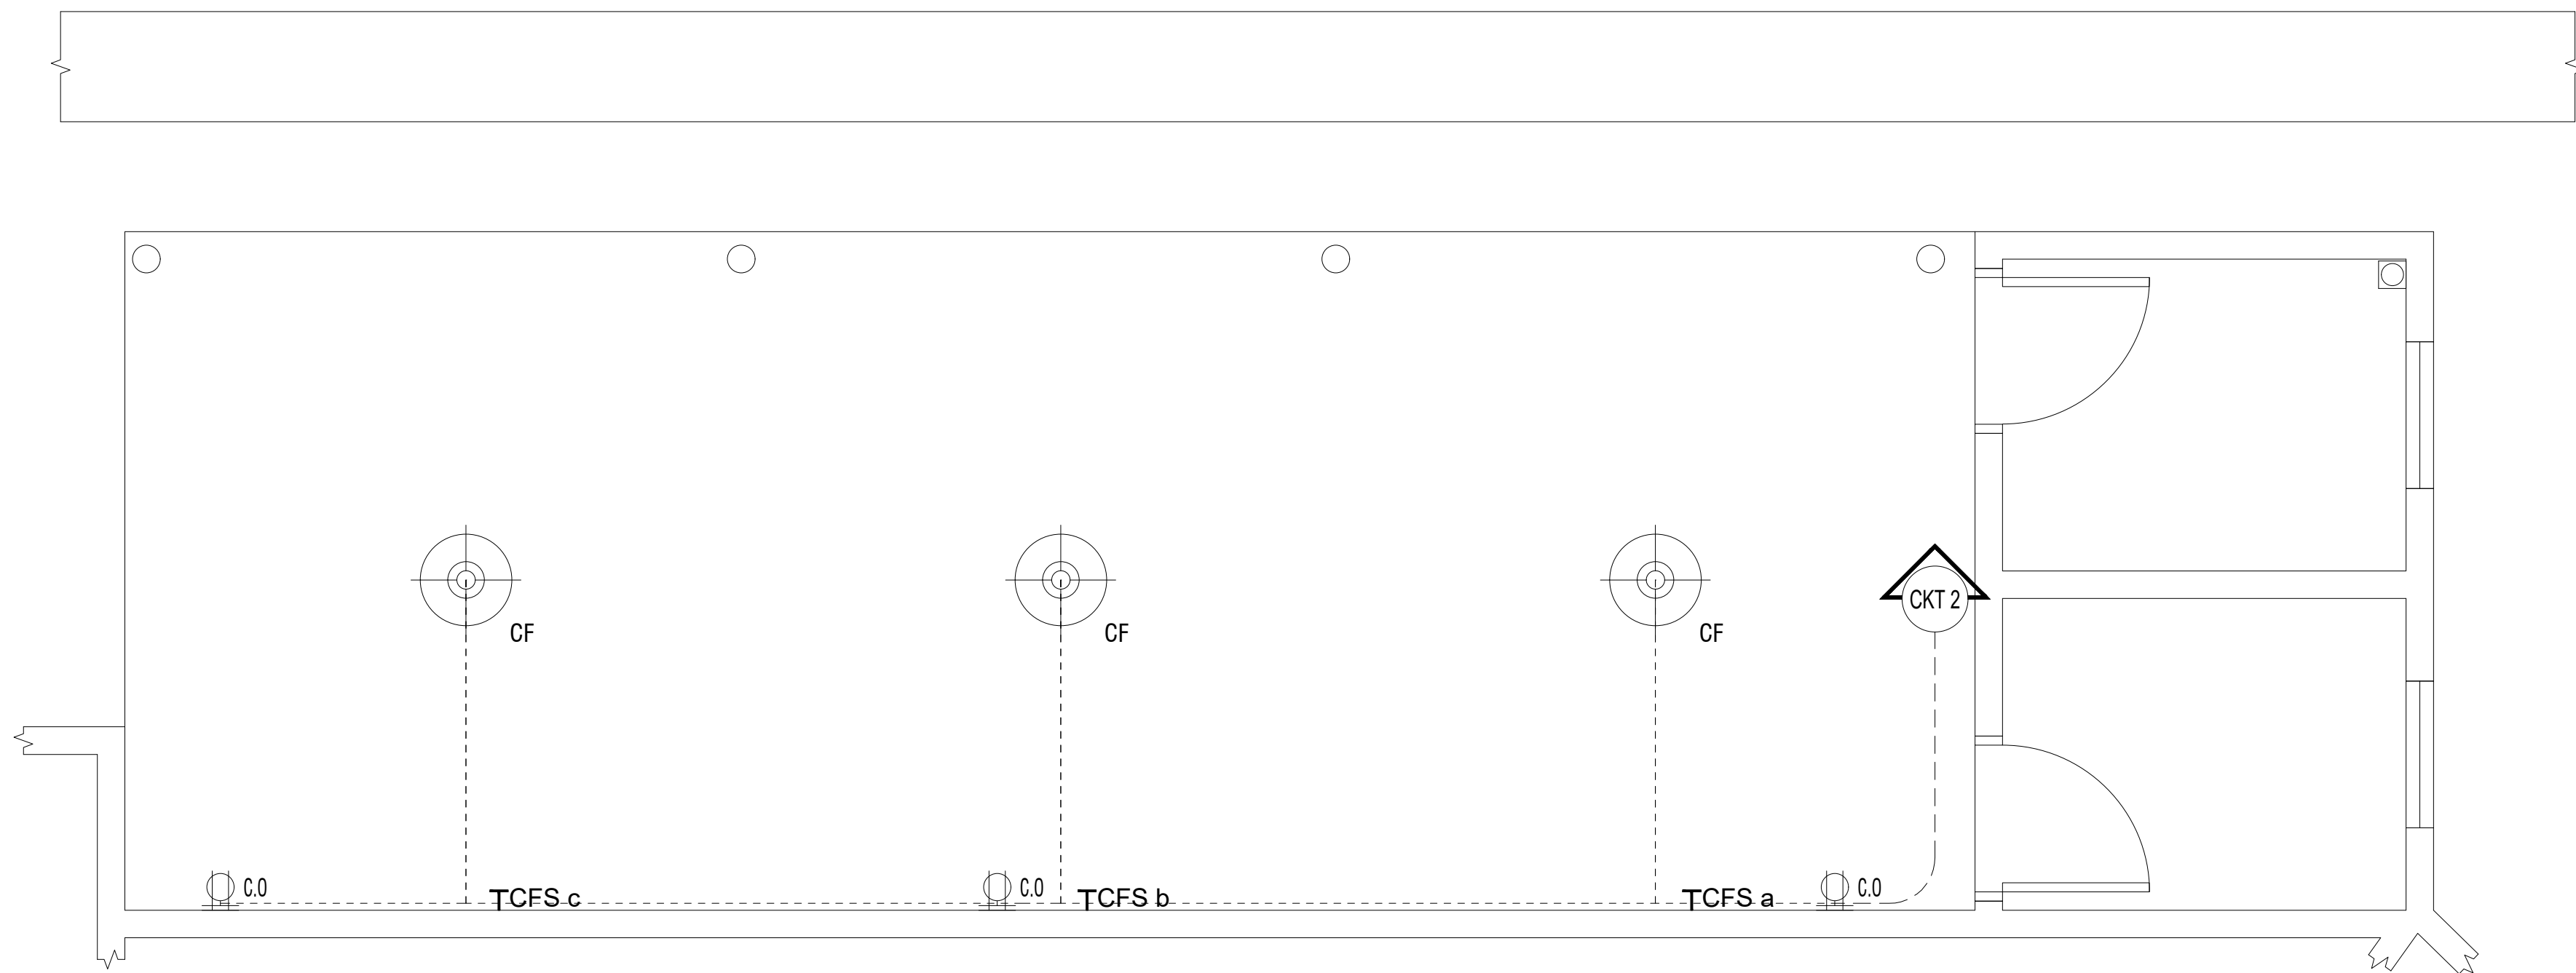

PAVILION 2 E.R
S **PROPOSED POWERLINE LAY OUT**
501 1:30M



REPUBLIC OF THE PHILIPPINES
Department Of Health
National Center for Mental Health
Nueve de Pebrero Street, Baranggay Mauway, Mandaluyong City

PROJECT TITLE/LOCATION:

PROVISION OF WAITING AREA AT PAVILION 2
EMERGENCY ROOM

PREPARED BY:

EVELYN T. PURINO, CE, MMHoA
SAO, Chief, Planning & Development Section

REVIEWED:

DIONICIO A. TOLENTINO, MPA
Chief Finance Service, HFEP Coordinator


RECOMMENDING APPROVAL:


NOEL V. REYES, MD, FPPA, MMHoA
Medical Center Chief II

SHEET CONTENT:


PROPOSED LIGHTING LAY OUT
PROPOSED POWER LINE LAY OUT

SHEET NO.

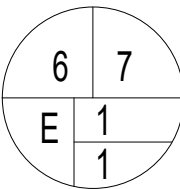

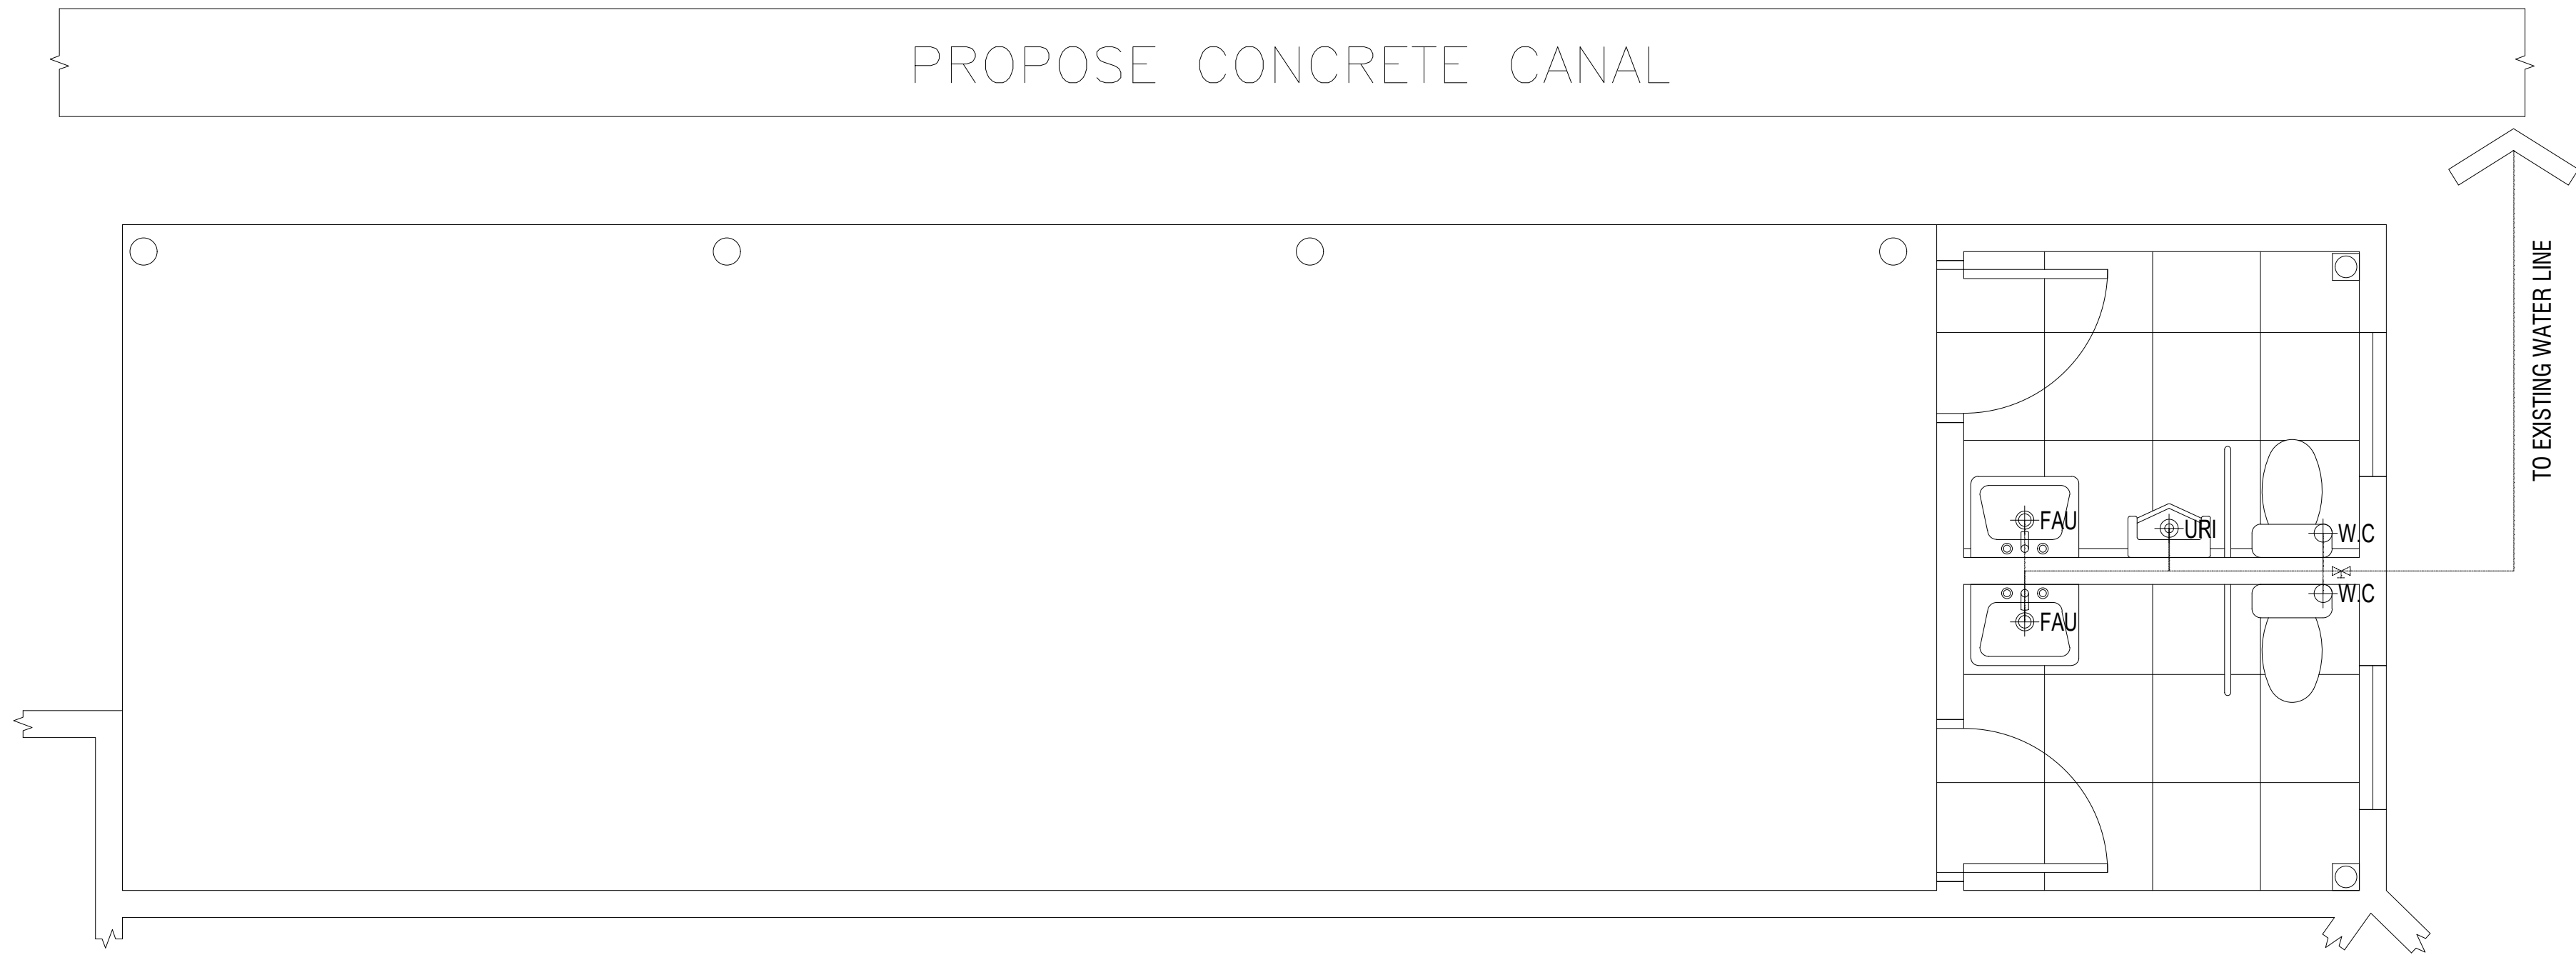

S PAVILION 2 E.R
501
PROPOSED WATERLINE LAY OUT
1:30M

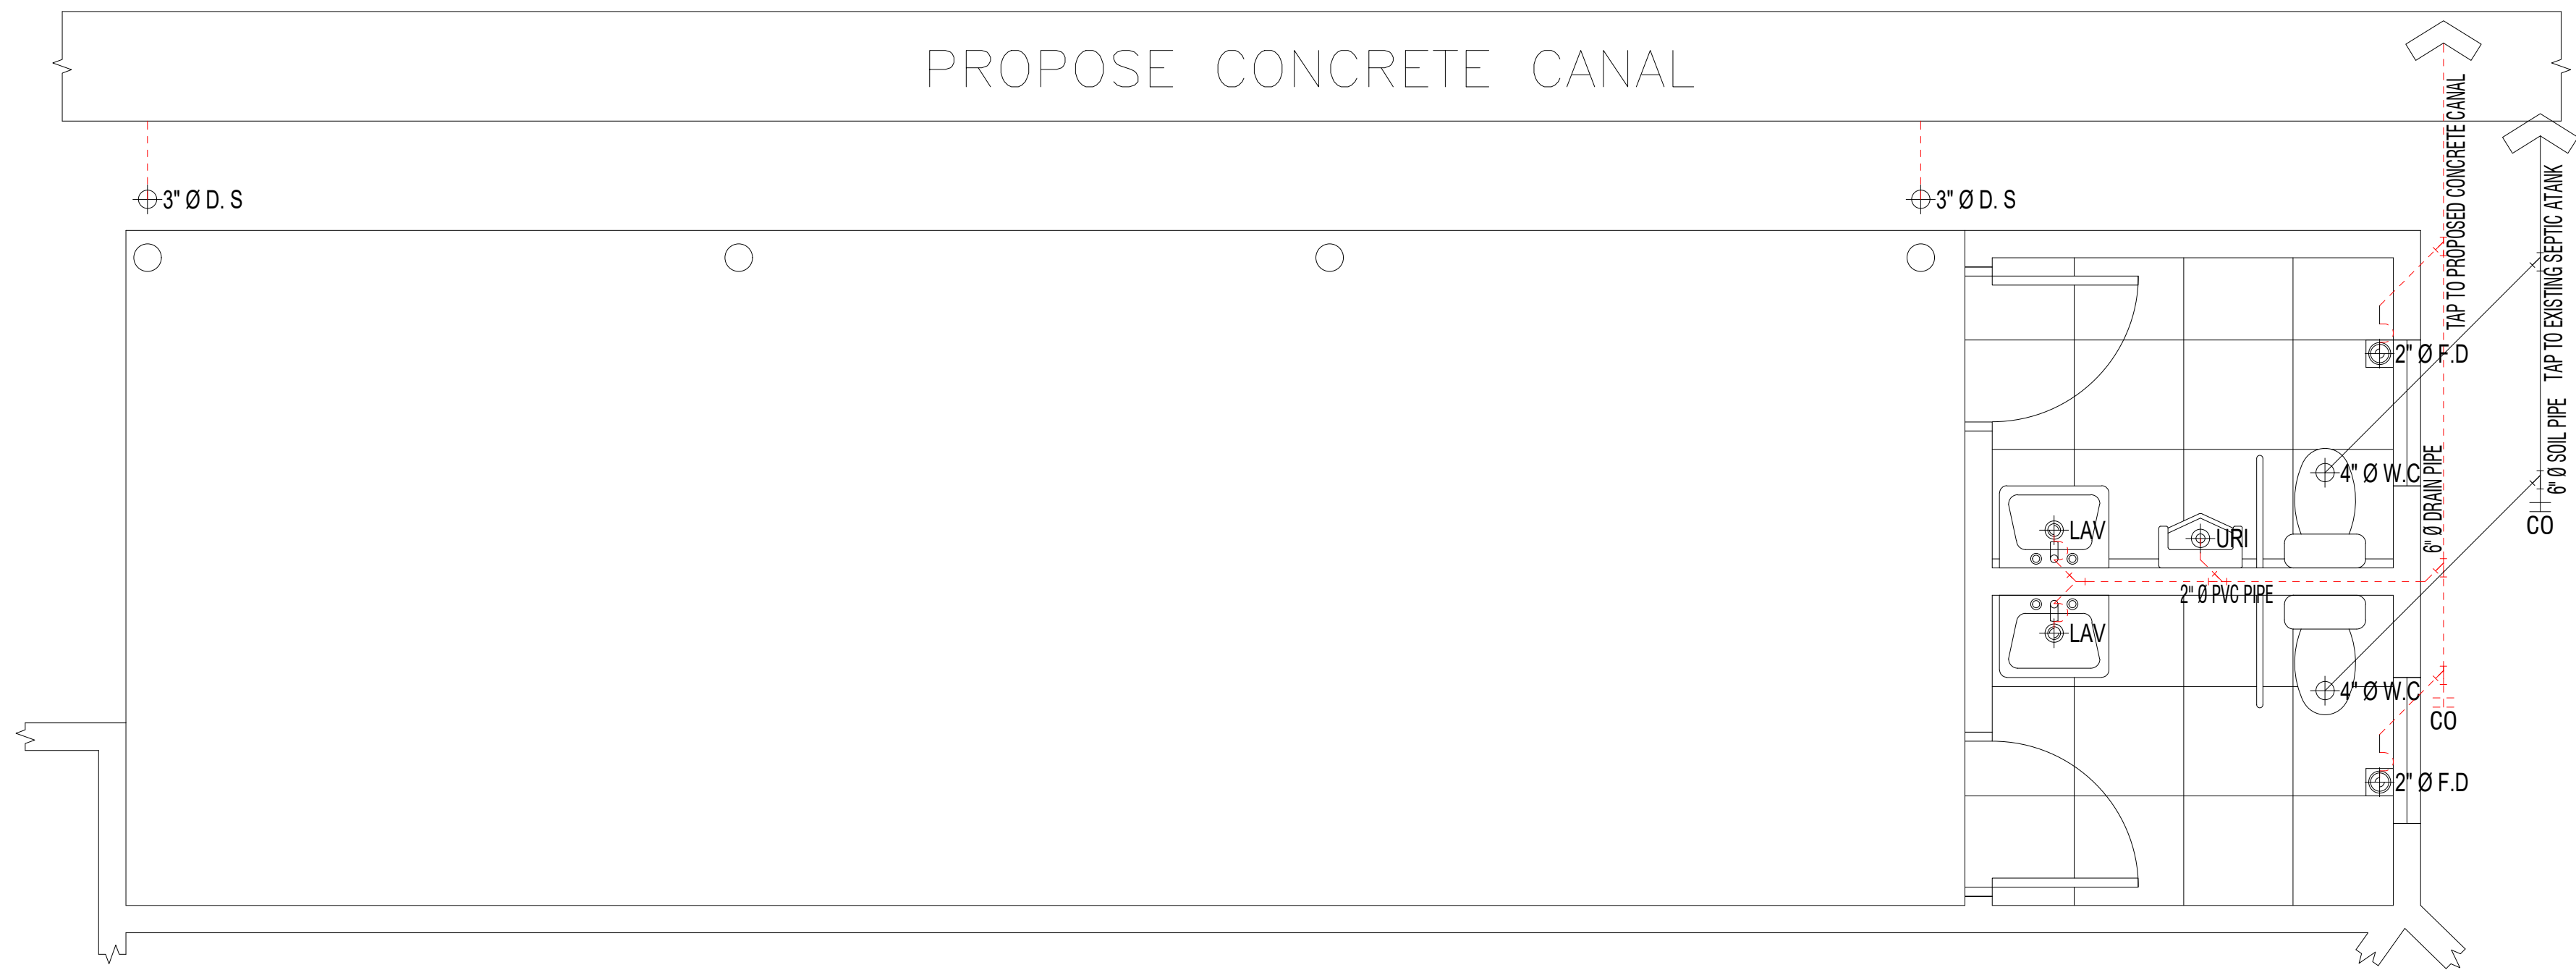

S PAVILION 2 E.R
501
PROPOSED SEWERLINE LAY OUT
1:30M



REPUBLIC OF THE PHILIPPINES
Department Of Health
National Center for Mental Health
Nueve de Pebrero Street, Baranggay Mauway, Mandaluyong City

PROJECT TITLE/LOCATION:

PROVISION OF WAITING AREA AT PAVILION 2
EMERGENCY ROOM

PREPARED BY:

EVELYN T. PURINO, CE, MMHoA
SAO, Chief, Planning & Development Section

REVIEWED:

DIONICIO A. TOLENTINO, MPA
Chief Finance Service, HFEP Coordinator


RECOMMENDING APPROVAL:


NOEL V. REYES, MD, FPPA, MMHoA
Medical Center Chief II

SHEET CONTENT:


PROPOSED WATERLINE LAY OUT
PROPOSED SEWERLINE LAY OUT

SHEET NO.

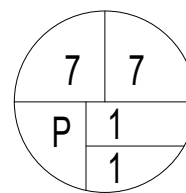


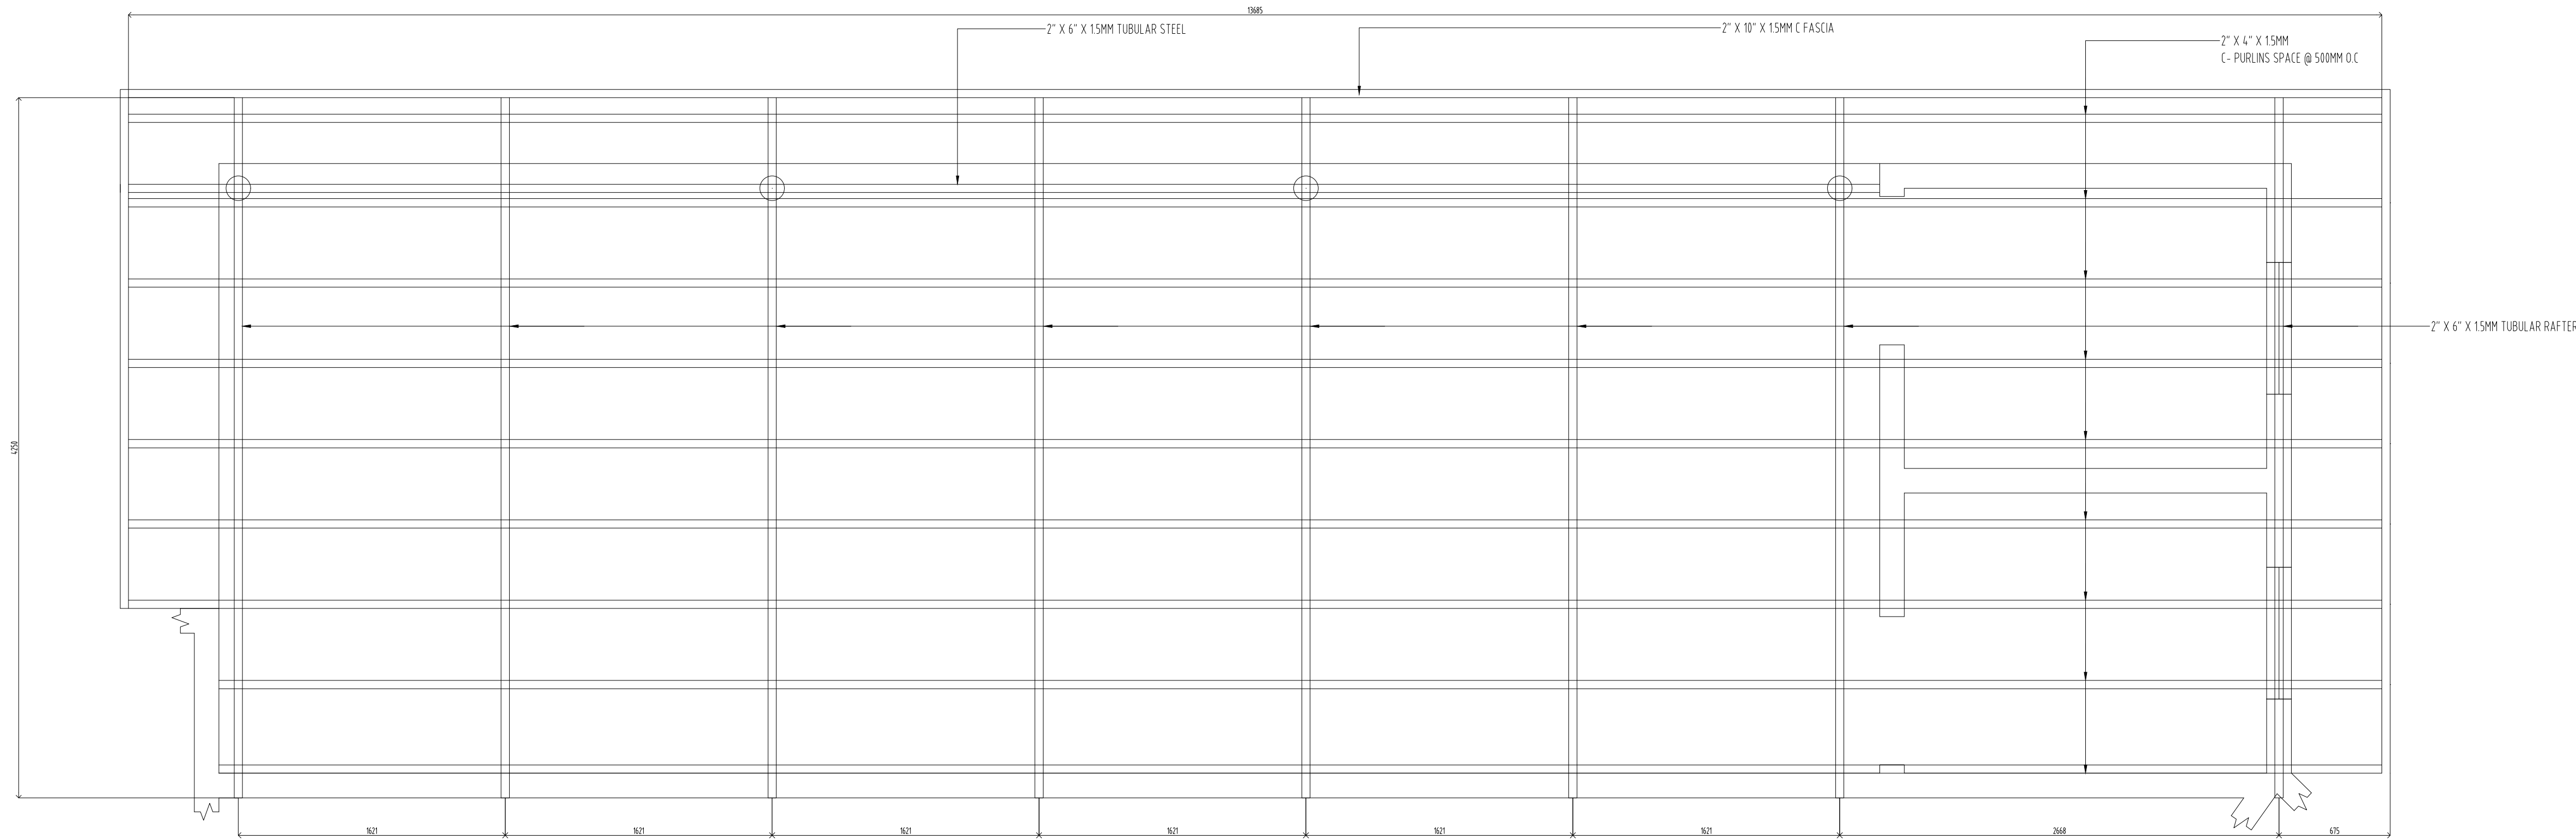


S
501
PAVILION 2
ROOF FRAMING PLAN
1:30M

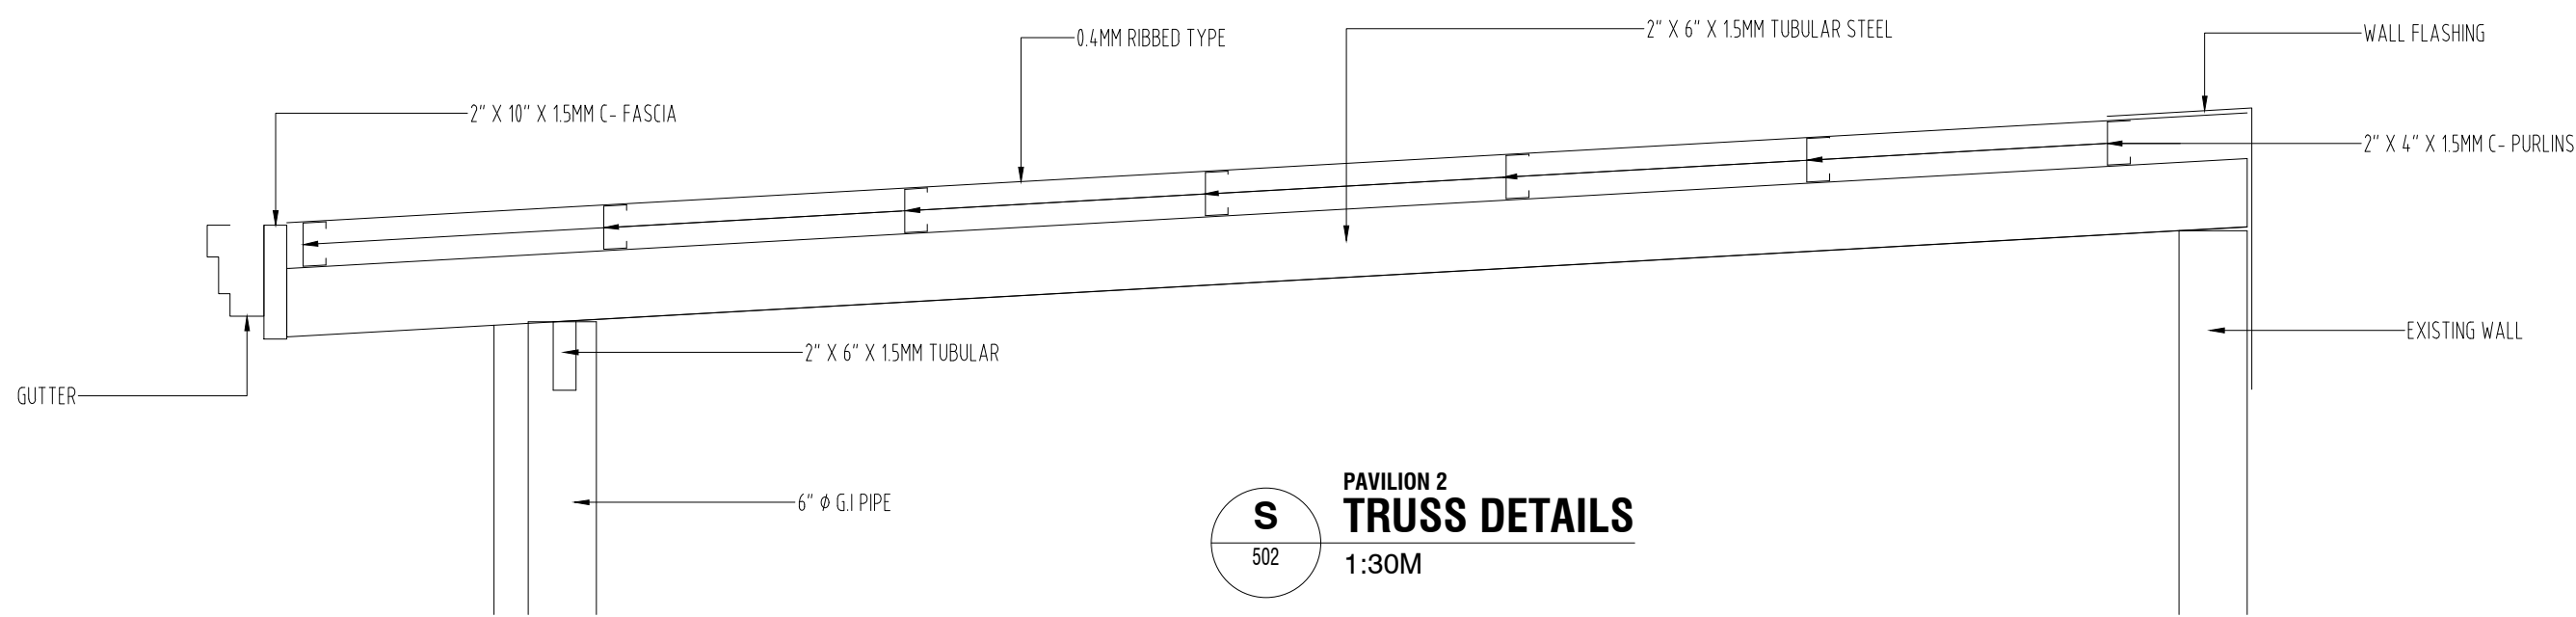

S
502
PAVILION 2
TRUSS DETAILS
1:30M

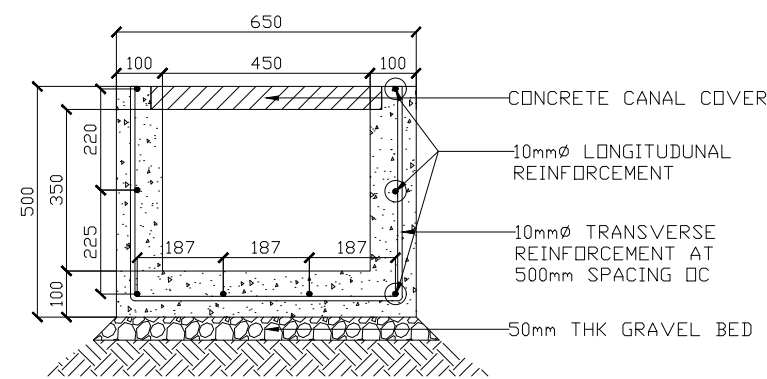

S
503
EMERGENCY ROOM EXTENSION
CONCRETE CANAL DETAILS
NTS

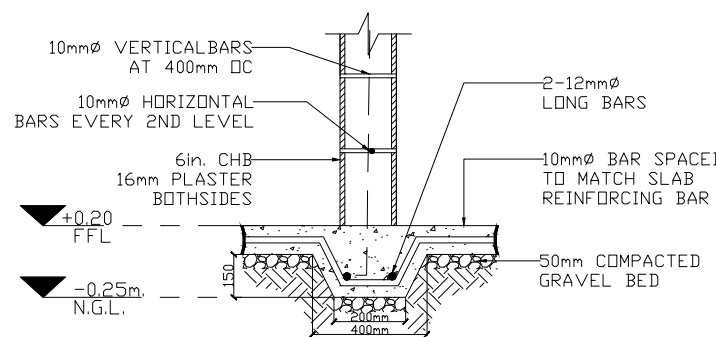

S
504
EMERGENCY ROOM EXTENSION
WALL FOOTING 1 (WF1) DETAILS
NTS



REPUBLIC OF THE PHILIPPINES
Department Of Health

National Center for Mental Health

Nueve de Pebrero Street, Baranggay Mauway, Mandaluyong City

PROJECT TITLE/LOCATION:

PROVISION OF WAITING AREA AT PAVILION 2
EMERGENCY ROOM

PREPARED BY:

EVELYN T. PURINO, CE, MMHoA
SAO, Chief, Planning & Development Section

REVIEWED:

DIONICIO A. TOLENTINO, MPA
Chief Finance Service, HFEP Coordinator

RECOMMENDING APPROVAL:

NOEL V. REYES, MD, FPPA, MMHoA
Medical Center Chief II

SHEET CONTENT:

ROOF FRAMING PLAN
TRUSS DETAILS
CONCRETE CANAL DETAILS,WF1 DETAILS

SHEET NO.

